


ASML LITHOGRAPHY
77 DANBURY ROAD WILTON, CT
WEST ADDITION

H & R DESIGN
FACILITIES
PLANNERS

DESIGN
INTERIORS
LANDSCAPE

55 GEORGE STREET, DANIEL, VT 05101
PH 203-794-6700 FAX 203-794-6303

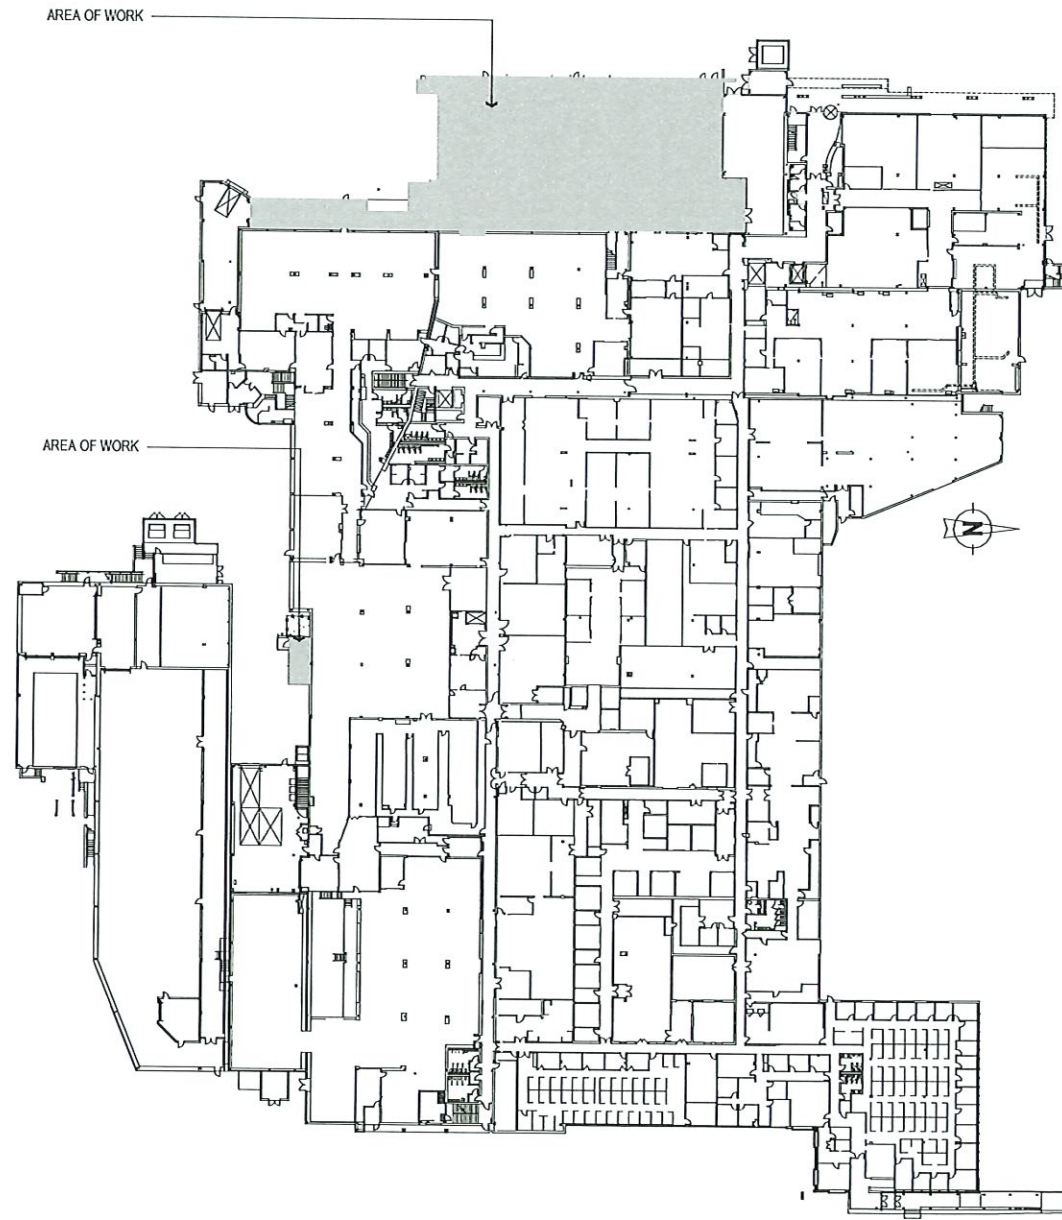

KEY PLAN
SCALE: NOT TO SCALE

[illegible]

12/18/21	DESIGN DEVELOPMENT ISSUE
Issue & Revision List	
ASV, Ref. No.	

ASML


77 DANBURY ROAD
WILTON, CT 06897

WEST ADDITION

Date	10.10.21	Drawn By	
Scale	AS NOTED	Approved By	S.Y.
Job No	21014	File	in accordance with the approved design information, etc.
Drawing Title:			
COVER SHEET			

COPYRIGHT:

Drawing Number:
A001

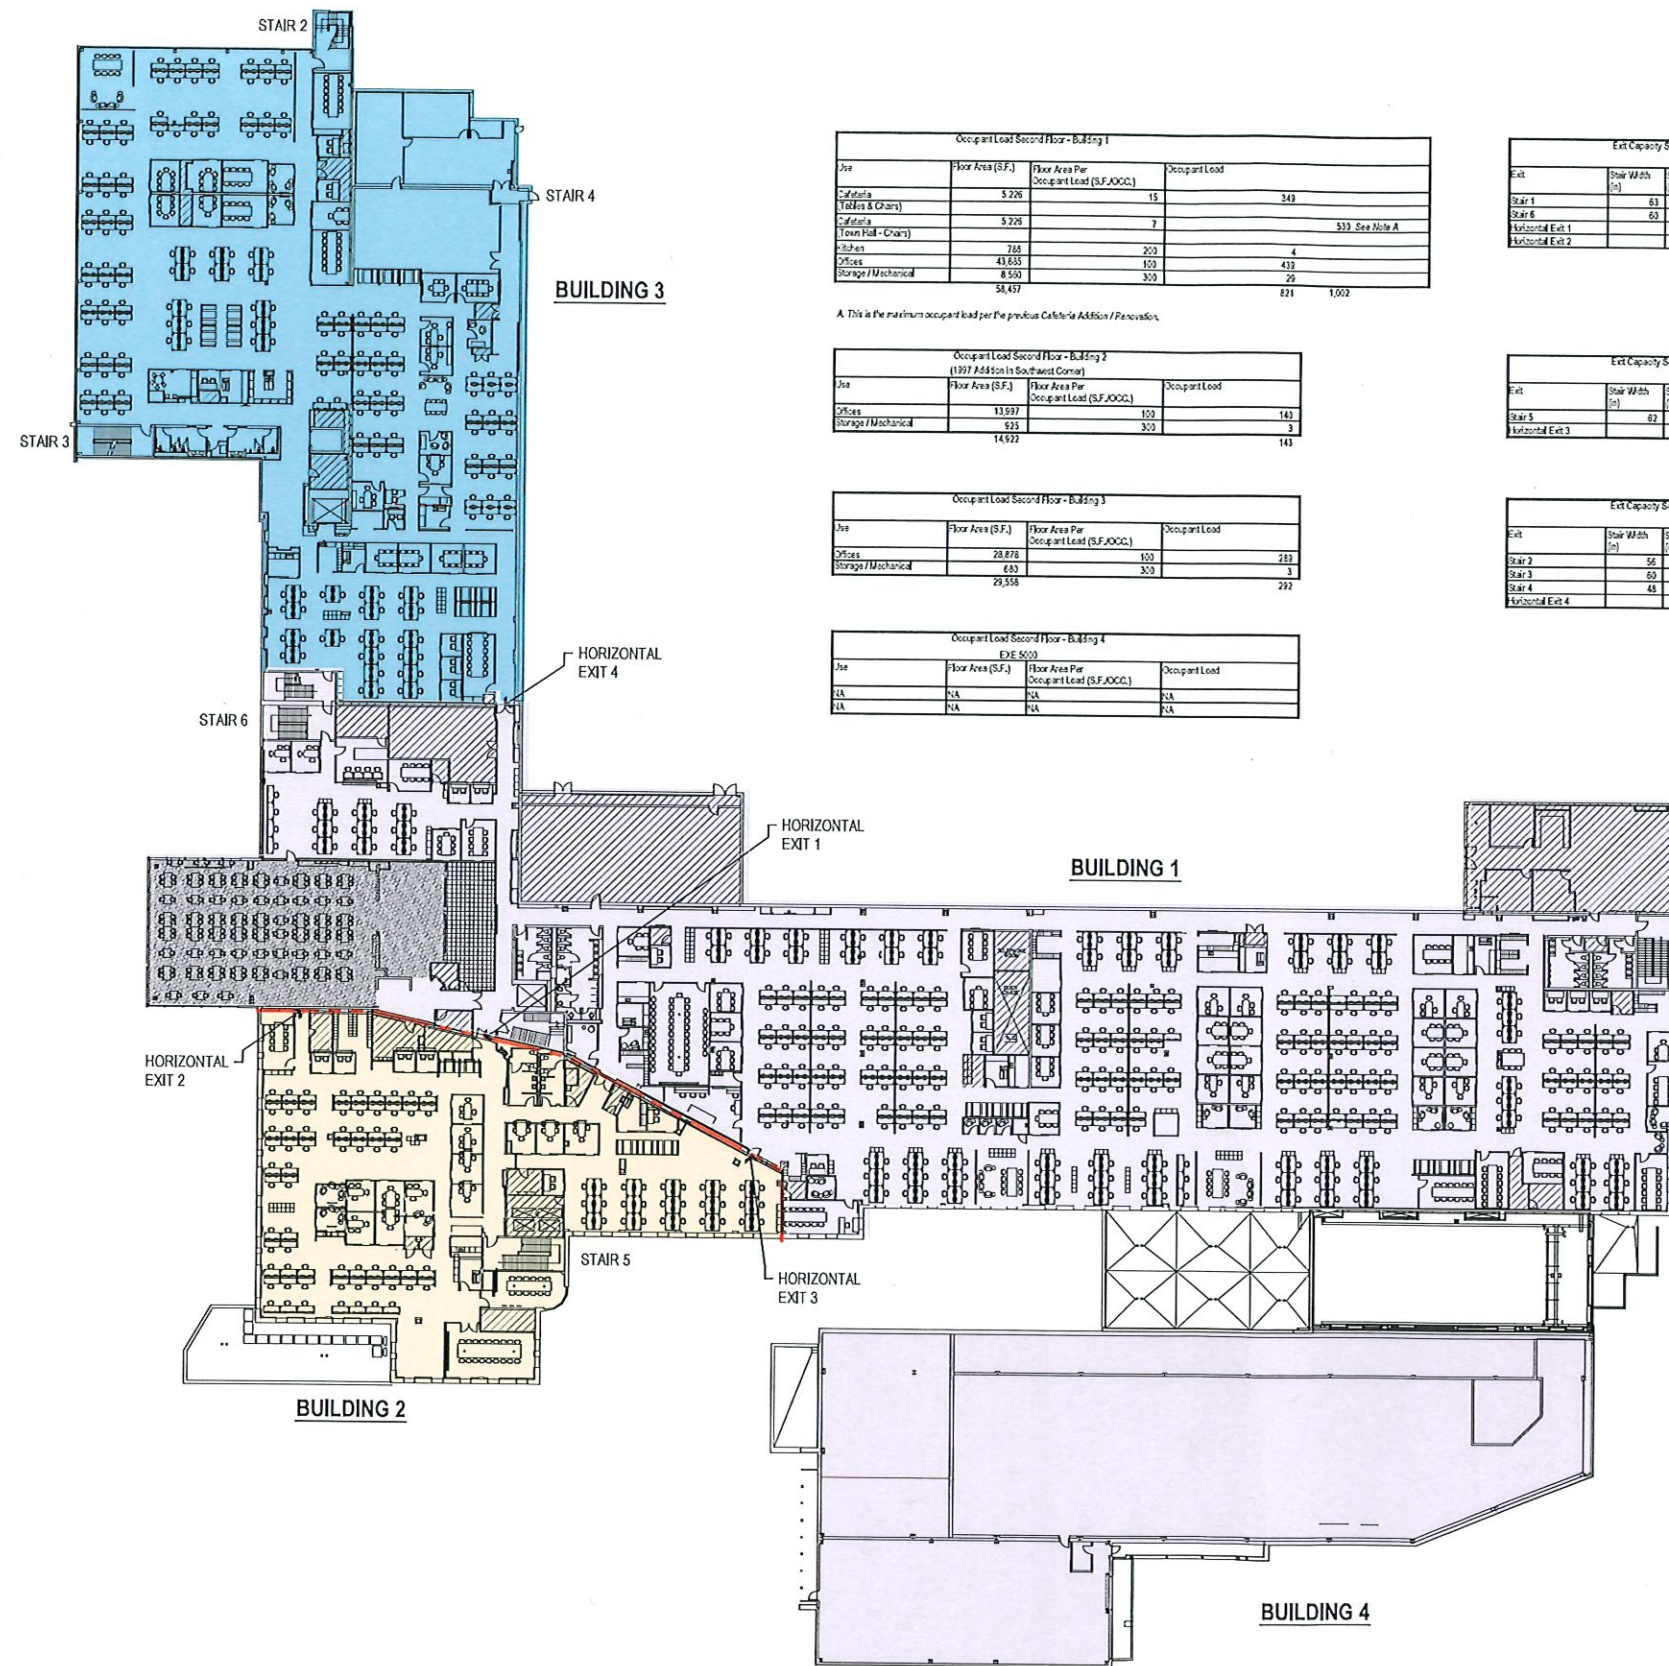

Occupant Load Second Floor - Building 1			
Use	Floor Area (S.F.)	Floor Area Per Occupant Load (S.F./OCC.)	Occupant Load
Cafeteria	5,226	15	348
Tables & Chairs			
Cafeteria	5,226	7	533 See Note A
Open Hall - Chairs			
Kitchen	768	200	4
Offices	43,835	100	438
Storage / Mechanical	8,550	300	29
	58,457		821 1,002

A. This is the maximum occupant load per the previous California Addition / Renovation.

Occupant Load Second Floor - Building 2			
EXE 5009 Addition in Southwest Corner			
Use	Floor Area (S.F.)	Floor Area Per Occupant Load (S.F./OCC.)	Occupant Load
Offices	13,997	100	140
Storage / Mechanical	925	300	3
	14,922		143

Occupant Load Second Floor - Building 3			
Use	Floor Area (S.F.)	Floor Area Per Occupant Load (S.F./OCC.)	Occupant Load
Offices	28,878	100	289
Storage / Mechanical	653	300	3
	29,531		292

Occupant Load Second Floor - Building 4			
EXE 5009			
Use	Floor Area (S.F.)	Floor Area Per Occupant Load (S.F./OCC.)	Occupant Load
NA	NA	NA	NA
NA	NA	NA	NA

Exit Capacity Second Floor - Building 1							
Exit	Stair Width (in)	Stair Exit Allowance (in/person)	Stair Capacity (persons)	Door Width (in)	Door Exit Allowance (in/person)	Door Capacity (persons)	Exit Capacity (persons)
Stair 1	63	0.3	210	45	0.2	200	200
Stair 6	63	0.3	210	45	0.2	200	200
Horizontal Exit 1				45	0.2	200	200
Horizontal Exit 2				45	0.2	200	200
							840

Exit Capacity Second Floor - Building 2							
Exit	Stair Width (in)	Stair Exit Allowance (in/person)	Stair Capacity (persons)	Door Width (in)	Door Exit Allowance (in/person)	Door Capacity (persons)	Exit Capacity (persons)
Stair 5	62	0.3	207	34	0.2	170	170
Horizontal Exit 3				34	0.2	170	170
							379

Exit Capacity Second Floor - Building 3							
Exit	Stair Width (in)	Stair Exit Allowance (in/person)	Stair Capacity (persons)	Door Width (in)	Door Exit Allowance (in/person)	Door Capacity (persons)	Exit Capacity (persons)
Stair 2	56	0.3	187	45	0.2	200	187
Stair 3	60	0.3	200	40	0.2	200	200
Stair 4	48	0.3	160	34	0.2	170	150
Horizontal Exit 4				63	0.2	340	340
							887

OCCUPANT LOAD DENSITIES (IBC TABLE 1004.1.2)	
S.F. PER OCCUPANT	BUILDING - AREA TYPE
15 NET S.F. / OCC.	BUILDING 1 - ASSEMBLY
100 S.F. / OCC.	BUILDING 1 - OFFICE AREA
200 S.F. / OCC.	BUILDING 1 - KITCHEN
300 S.F. / OCC.	BUILDING 1 - STORAGE / MECHANICAL
100 S.F. / OCC.	BUILDING 2 - OFFICE AREA
300 S.F. / OCC.	BUILDING 2 - STORAGE / MECHANICAL
	BUILDING 4 - EXE 5000
EXISTING FIRE WALL / FIRE BARRIER	

H & R DESIGN FACILITIES PLANNERS

DESIGN
INTERIORS
PLANNING

50 OSBORNE STREET, DANBURY, CT 06810
PH 203-799-9750 FAX 203-799-6933

Issue & Revision List:

ASML Ref. No.

ASML

77 DANBURY ROAD
WILTON, CT 06897

WEST ADDITION

Date: 10.19.21 Drawn By: -
Scale: 1/8" = 1'-0" Approved By: S.Y.
Job No: 19.072 File: with appropriate software and hardware
Drawing Title:

COPYRIGHT:
H & R Design, Inc. and its affiliates, reserve the right to use the name of the firm and its logo in any form or manner, and the right to be assigned to any third party, without releasing the copyright or other intellectual property rights in the design. The design is not to be used for any other purpose without the written consent of H & R Design, Inc. or its affiliates. Any unauthorized use of the design is prohibited. The design is not to be used for any other purpose without the written consent of H & R Design, Inc. or its affiliates. Any unauthorized use of the design is prohibited.

Drawing Number:

LS01

H & R DESIGN
FACILITIES
PLANNERS

DESIGN
INTERIORS
PLANNING

50 OSBORNE STREET, DANBURY, CT 06810
PH: 203-793-9710 FAX: 203-793-6953

Issue & Revision List:

ASML Ref. No.

ASML

77 DANBURY ROAD
WILTON, CT 06897

WEST ADDITION

Date: 10.19.21 Drawn By: -
Scale: 1/8" = 1'-0" Approved By: S.Y.
Job No: 19/072 File: H&R Design - West Addition - 10/19/21


Drawing Title:

COPYRIGHT:

H & R Design hereby expressly reserves the copyright and other property rights in these plans. These plans are not to be reproduced in any form or manner, nor are they to be assigned to any third party, without the express written permission and consent of H & R Design. Drawings and not be used for any other project without the express written permission of H & R Design. Any use of these plans without the express written permission of H & R Design is prohibited.

Drawing Number:

LS02

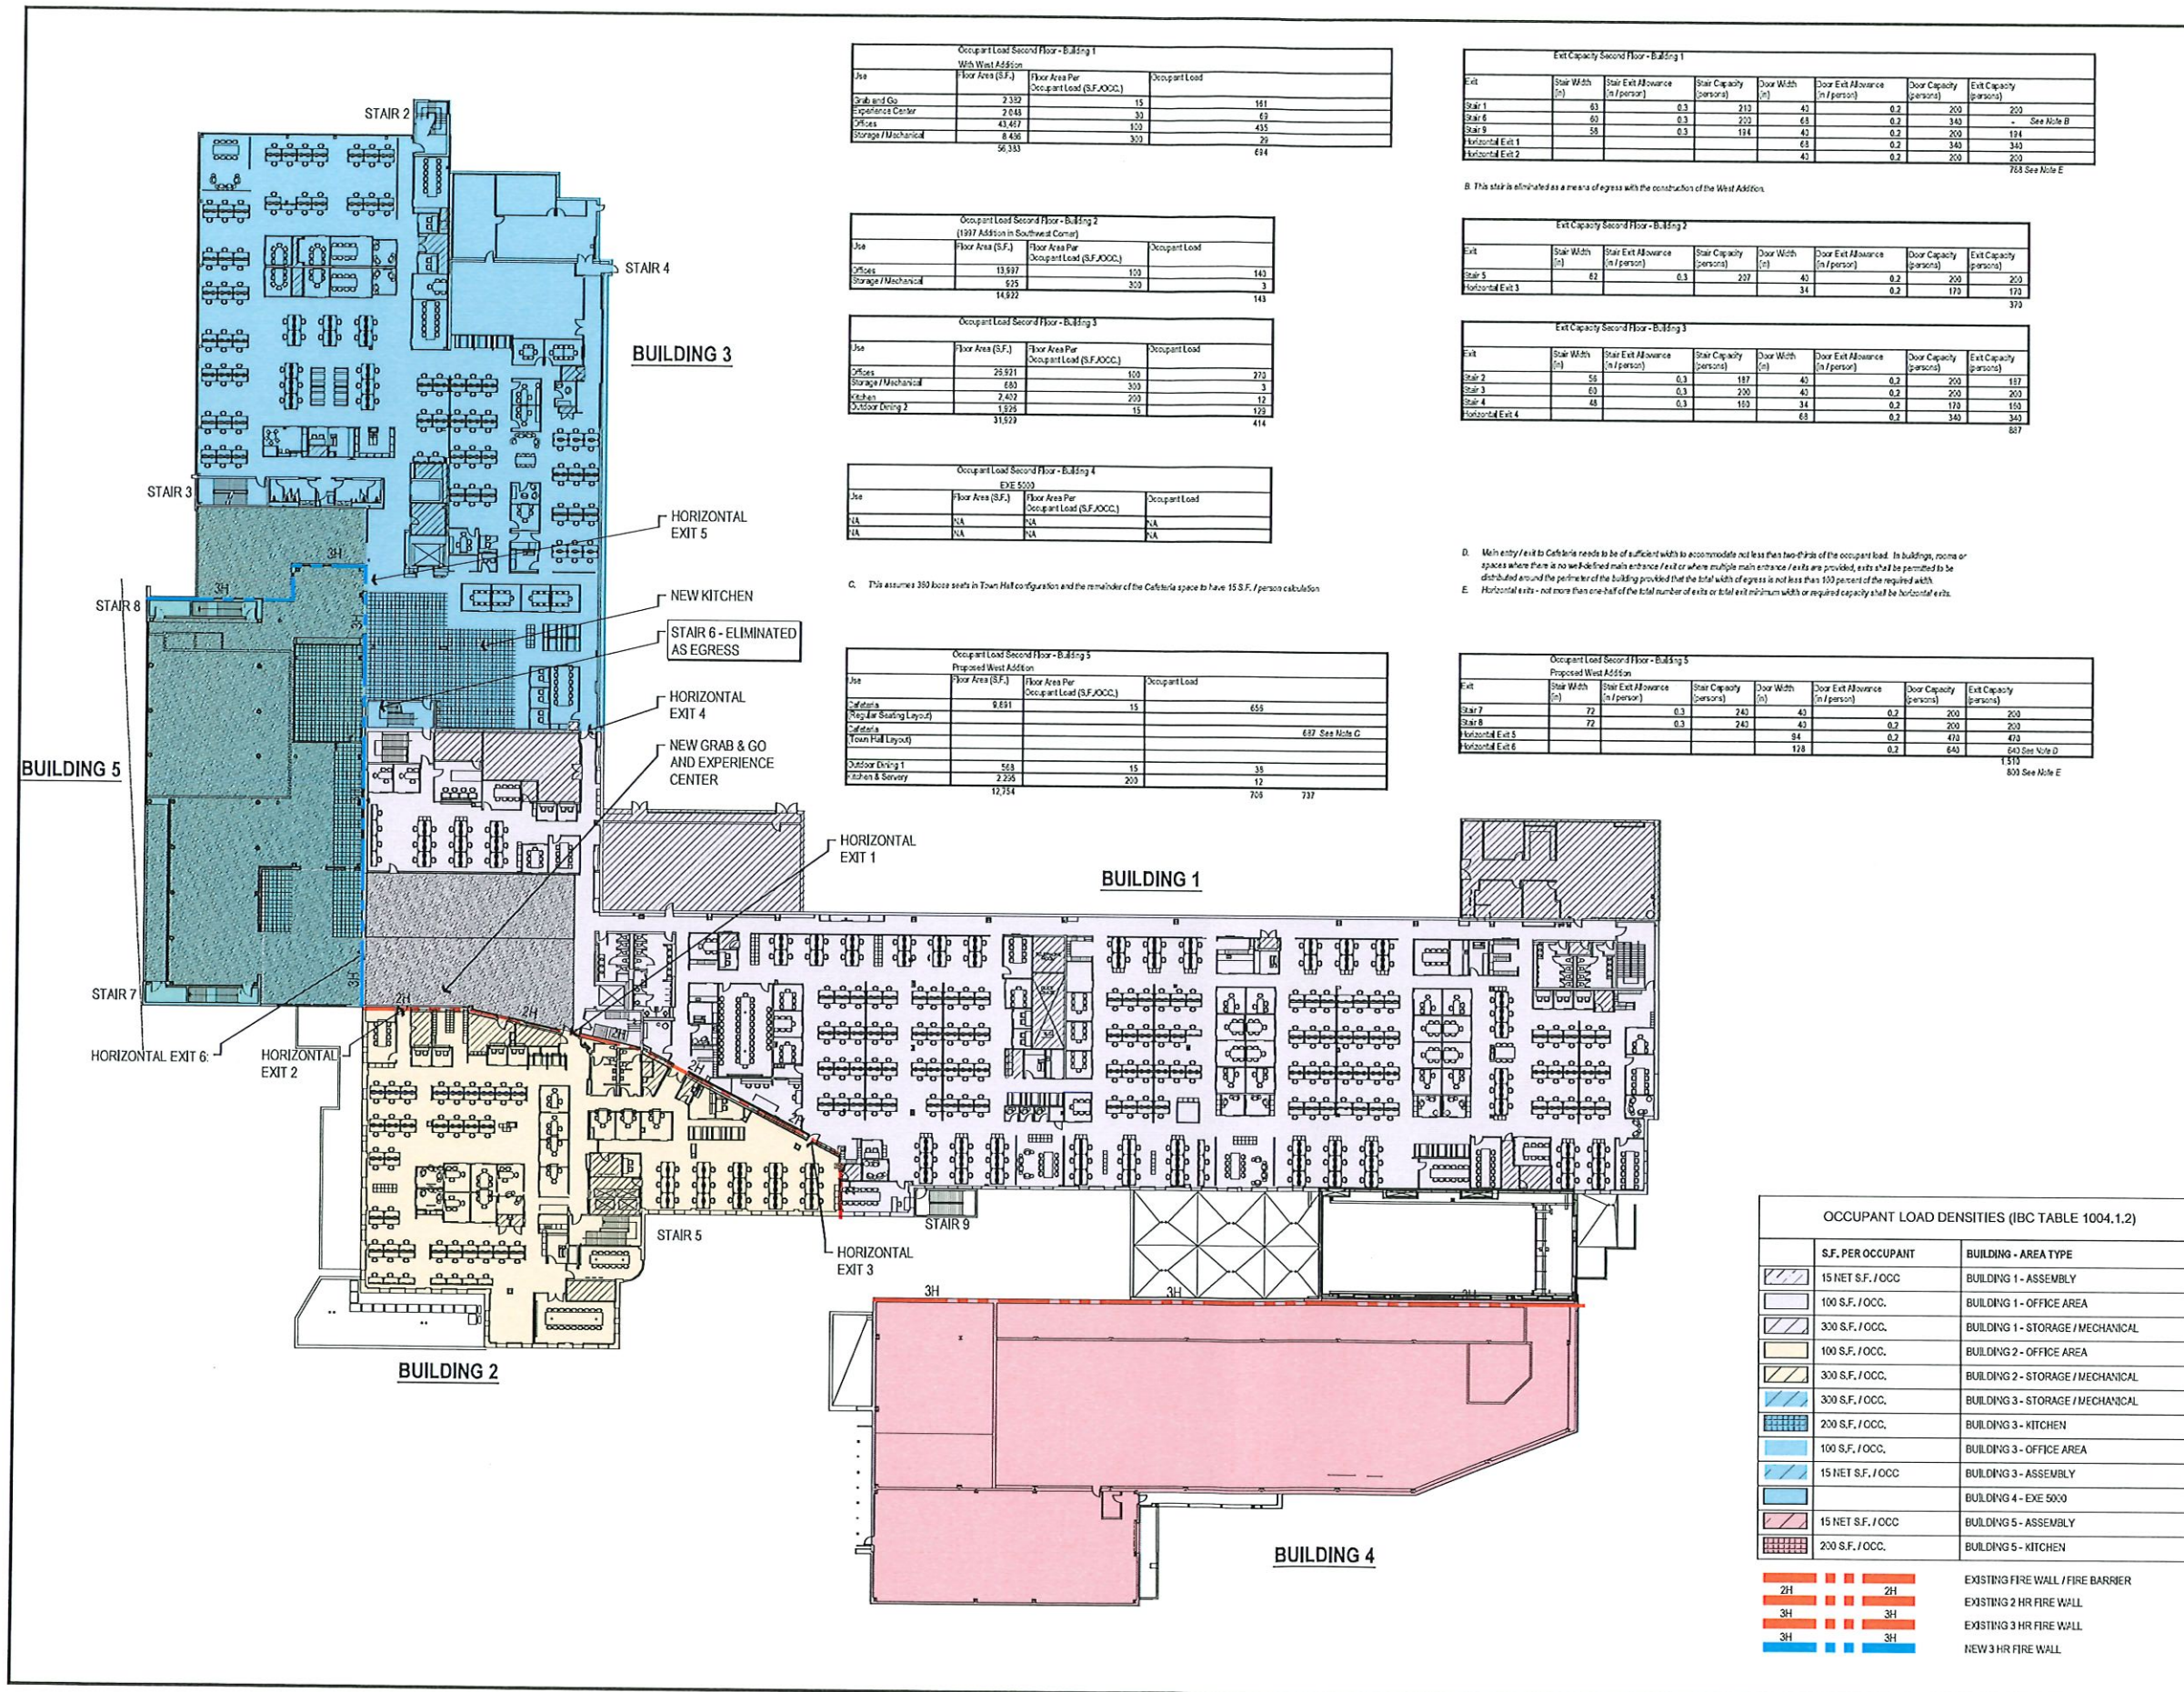

H & R DESIGN
FACILITIES
PLANNERS

DESIGN
INTERIORS
PLANNING

59 OSBORNE STREET, DANBURY, CT 06810
PH: 203-799-7170 FAX: 203-799-6151

Issue & Revision List:
ASML Ref. No.

ASML

77 DANBURY ROAD
MILTON, CT 06897


WEST ADDITION

Date: 10.19.21 Drawn By: -
Scale: 1/8" = 1'-0" Approved By: S.Y.
Job No: 17/085 File: 17/085

Drawing Title:
WEST ADDITION - PROPOSED
SECOND FLOOR PLAN EGRESS
PLAN

COPYRIGHT:
H & R Design Architects, Inc. is the owner of the copyright and other
rights in this plan. These plans are not to be reproduced in any form or
manner, nor may they be assigned to any third party without the written
consent of H & R Design Architects, Inc. Any reproduction or use of these
plans without the written consent of H & R Design Architects, Inc. is
prohibited. Any use of these plans for any purpose other than that
intended is prohibited.

Drawing Number:
LS03

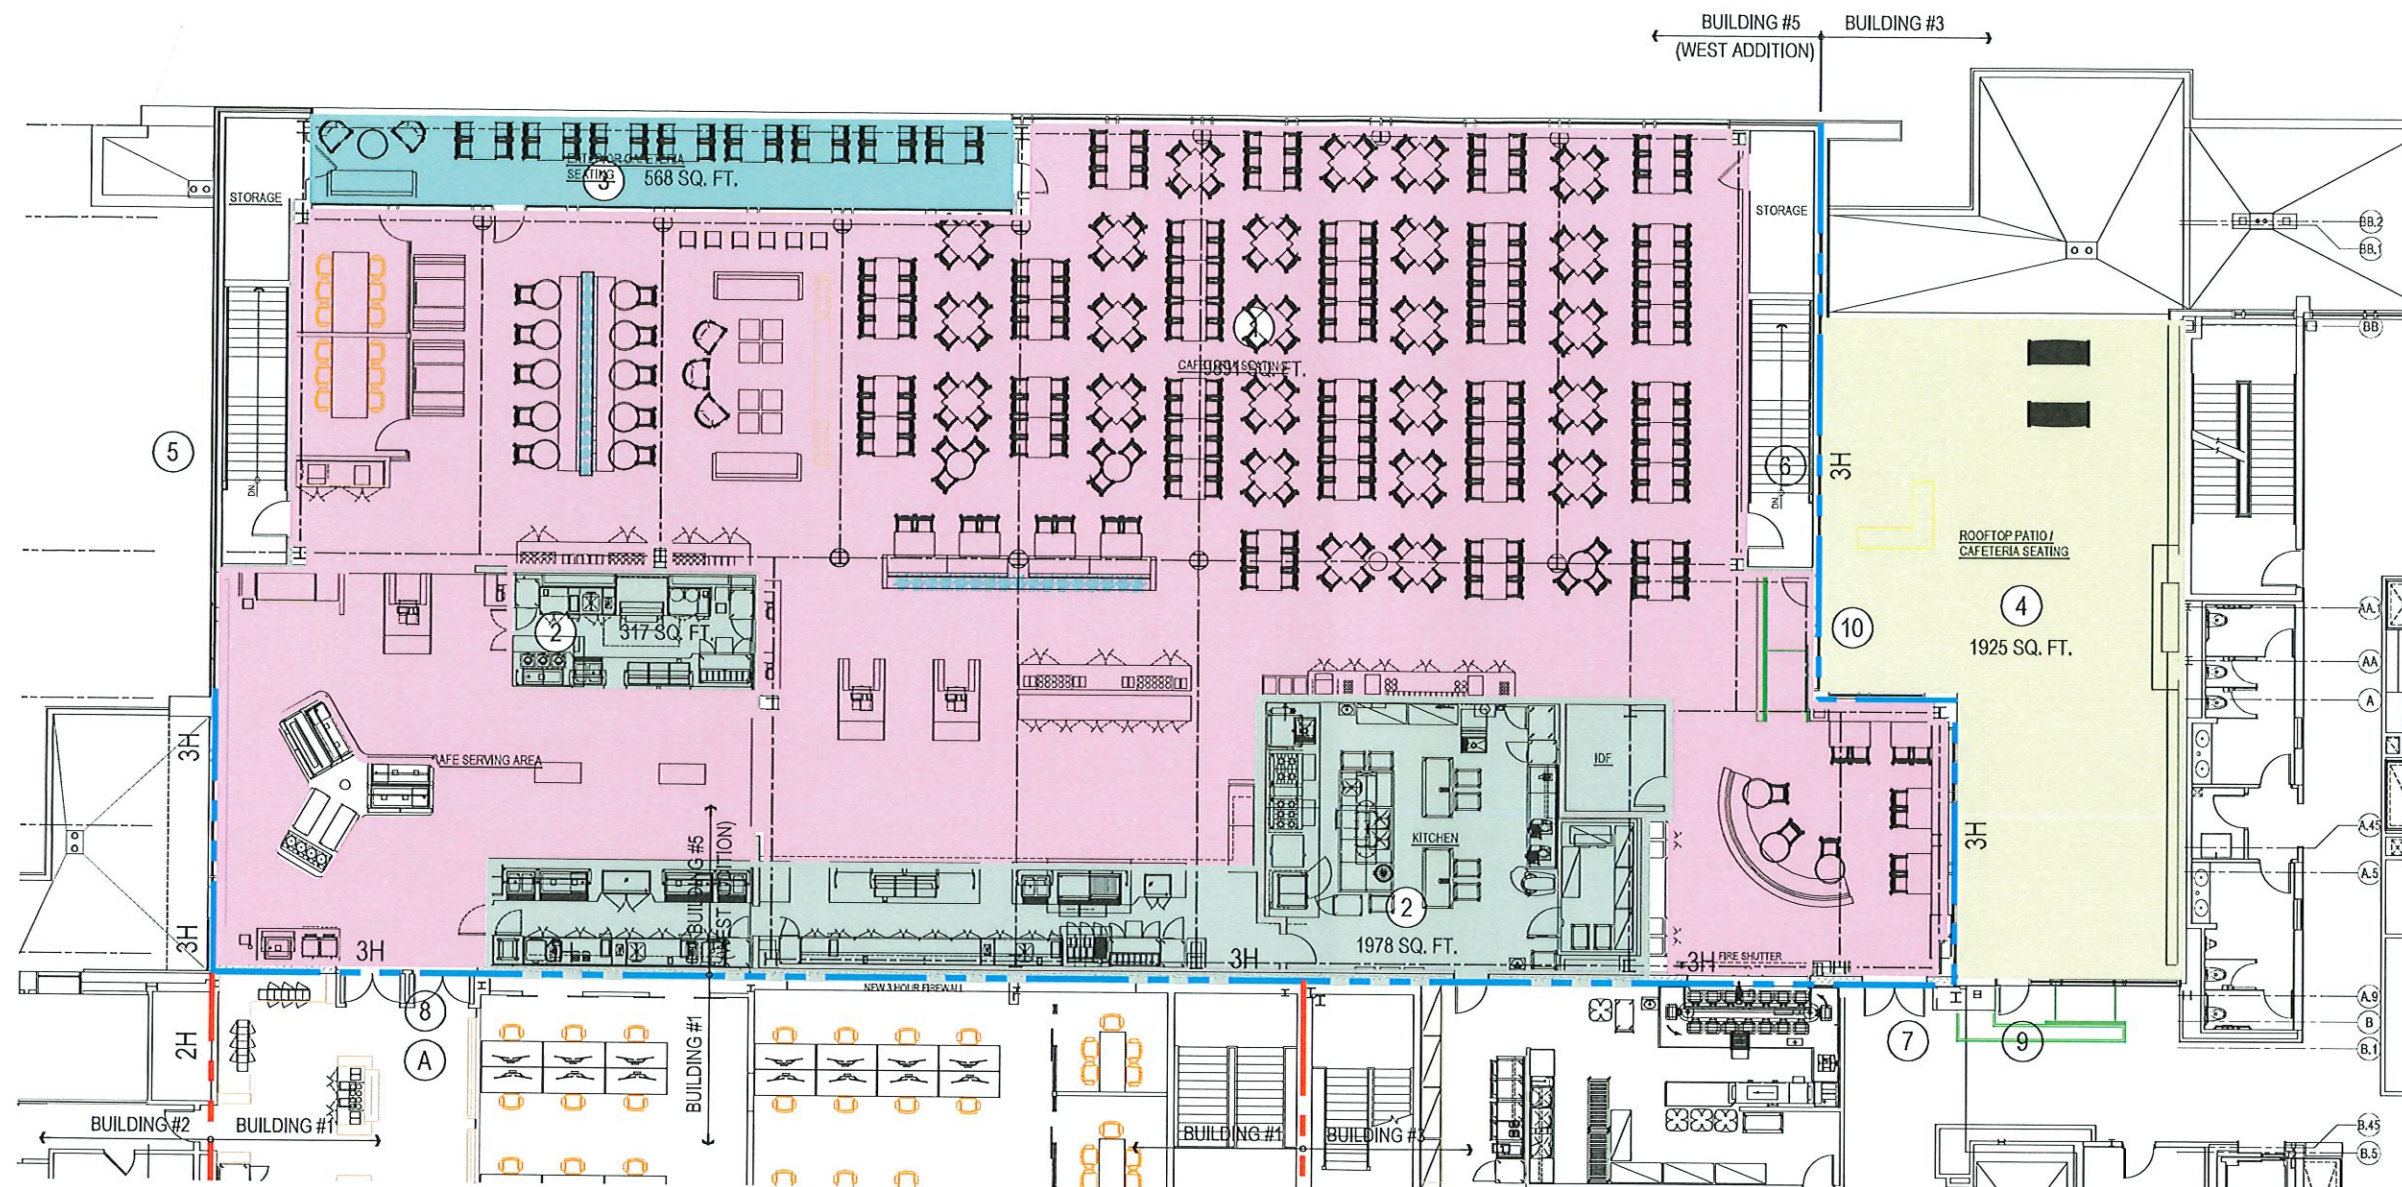

LEGEND:
AREA

- 1 CAFETERIA SEATING:
9,891 SQ. FT. / 115
- 2 KITCHEN PREP AREA:
2,295 SQ. FT. / 200
- 3 CAFETERIA FIXED SEATING - OUTDOOR:
568 SQ. FT. / 115
- 4 ROOFTOP FIXED SEATING - OUTDOOR:
1,925 SQ. FT. / 115

OCCUPANT LOAD	
1	656
2	12
3	38
4	129
TOTAL OCCUPANT LOAD: (WEST ADDITION / BUILDING #5)	
737	


- 5 CAFETERIA EXIT 1:
1 HR. FIRE RATED EXIT STAIR
75" WIDE - 250 PERSON EGRESS CAPACITY
40" DOOR - 200 PERSON EGRESS CAPACITY
- 6 CAFETERIA EXIT 2:
1 HR. FIRE RATED EXIT STAIR
75" WIDE - 250 PERSON EGRESS CAPACITY
40" DOOR - 200 PERSON EGRESS CAPACITY
- 7 CAFETERIA EXIT 3 (HORIZONTAL EXIT):
3 HR. FIRE RATED EXIT DOOR - SELF CLOSING & LATCHING ON
MAGNETIC HOLD-BACKS
96" DOOR - 470 PERSON EGRESS CAPACITY
- 8 CAFETERIA EXIT 4 (HORIZONTAL EXIT):
3 HR. FIRE RATED EXIT DOOR - SELF CLOSING & LATCHING ON
MAGNETIC HOLD-BACKS
128" DOOR - 640 PERSON EGRESS CAPACITY
- 9 OUTDOOR SEATING EXIT 1:
SELF CLOSING & LATCHING
- 10 OUTDOOR SEATING EXIT 2:
SELF CLOSING & LATCHING

EXIT CAPACITY:


200	3H	3H	NEW 3 HR FIRE WALL
200	2H	2H	EXISTING 2 HR FIRE WALL
470			EXISTING FIRE WALL / FIRE BARRIER
640			SEE NOTE A.
1,510			SEE NOTE B.

NOTES:


- A MAIN ENTRANCE / EXIT NEEDS TO ACCOMMODATE 2/3 OF THE OCCUPANT LOAD, MAXIMUM
OCCUPANT LOAD OF BUILDING 5 SHALL BE 800 PERSONS. 800 X .67 = 536 PERSONS OR 107.2' EGRESS
WIDTH (536 X 0.2 = 107.2) THAT NEEDS TO BE ACCOMMODATED BY THIS ENTRANCE / EXIT. THIS SHALL
BE TWO SETS OF DOUBLE FIRE DOORS ON HOLD-BACKS.
- B HORIZONTAL EXITS - NOT MORE THAN ONE-HALF OF THE TOTAL NUMBER OF EXITS OR TOTAL
EXIT MINIMUM WIDTH OR REQUIRED CAPACITY SHALL BE HORIZONTAL EXITS. THIS MEANS
TOTAL CAPACITY OF CAFETERIA EXITS 3 AND 4 CAN ONLY EQUAL HALF OF THE REQUIRED
EGRESS CAPACITY.

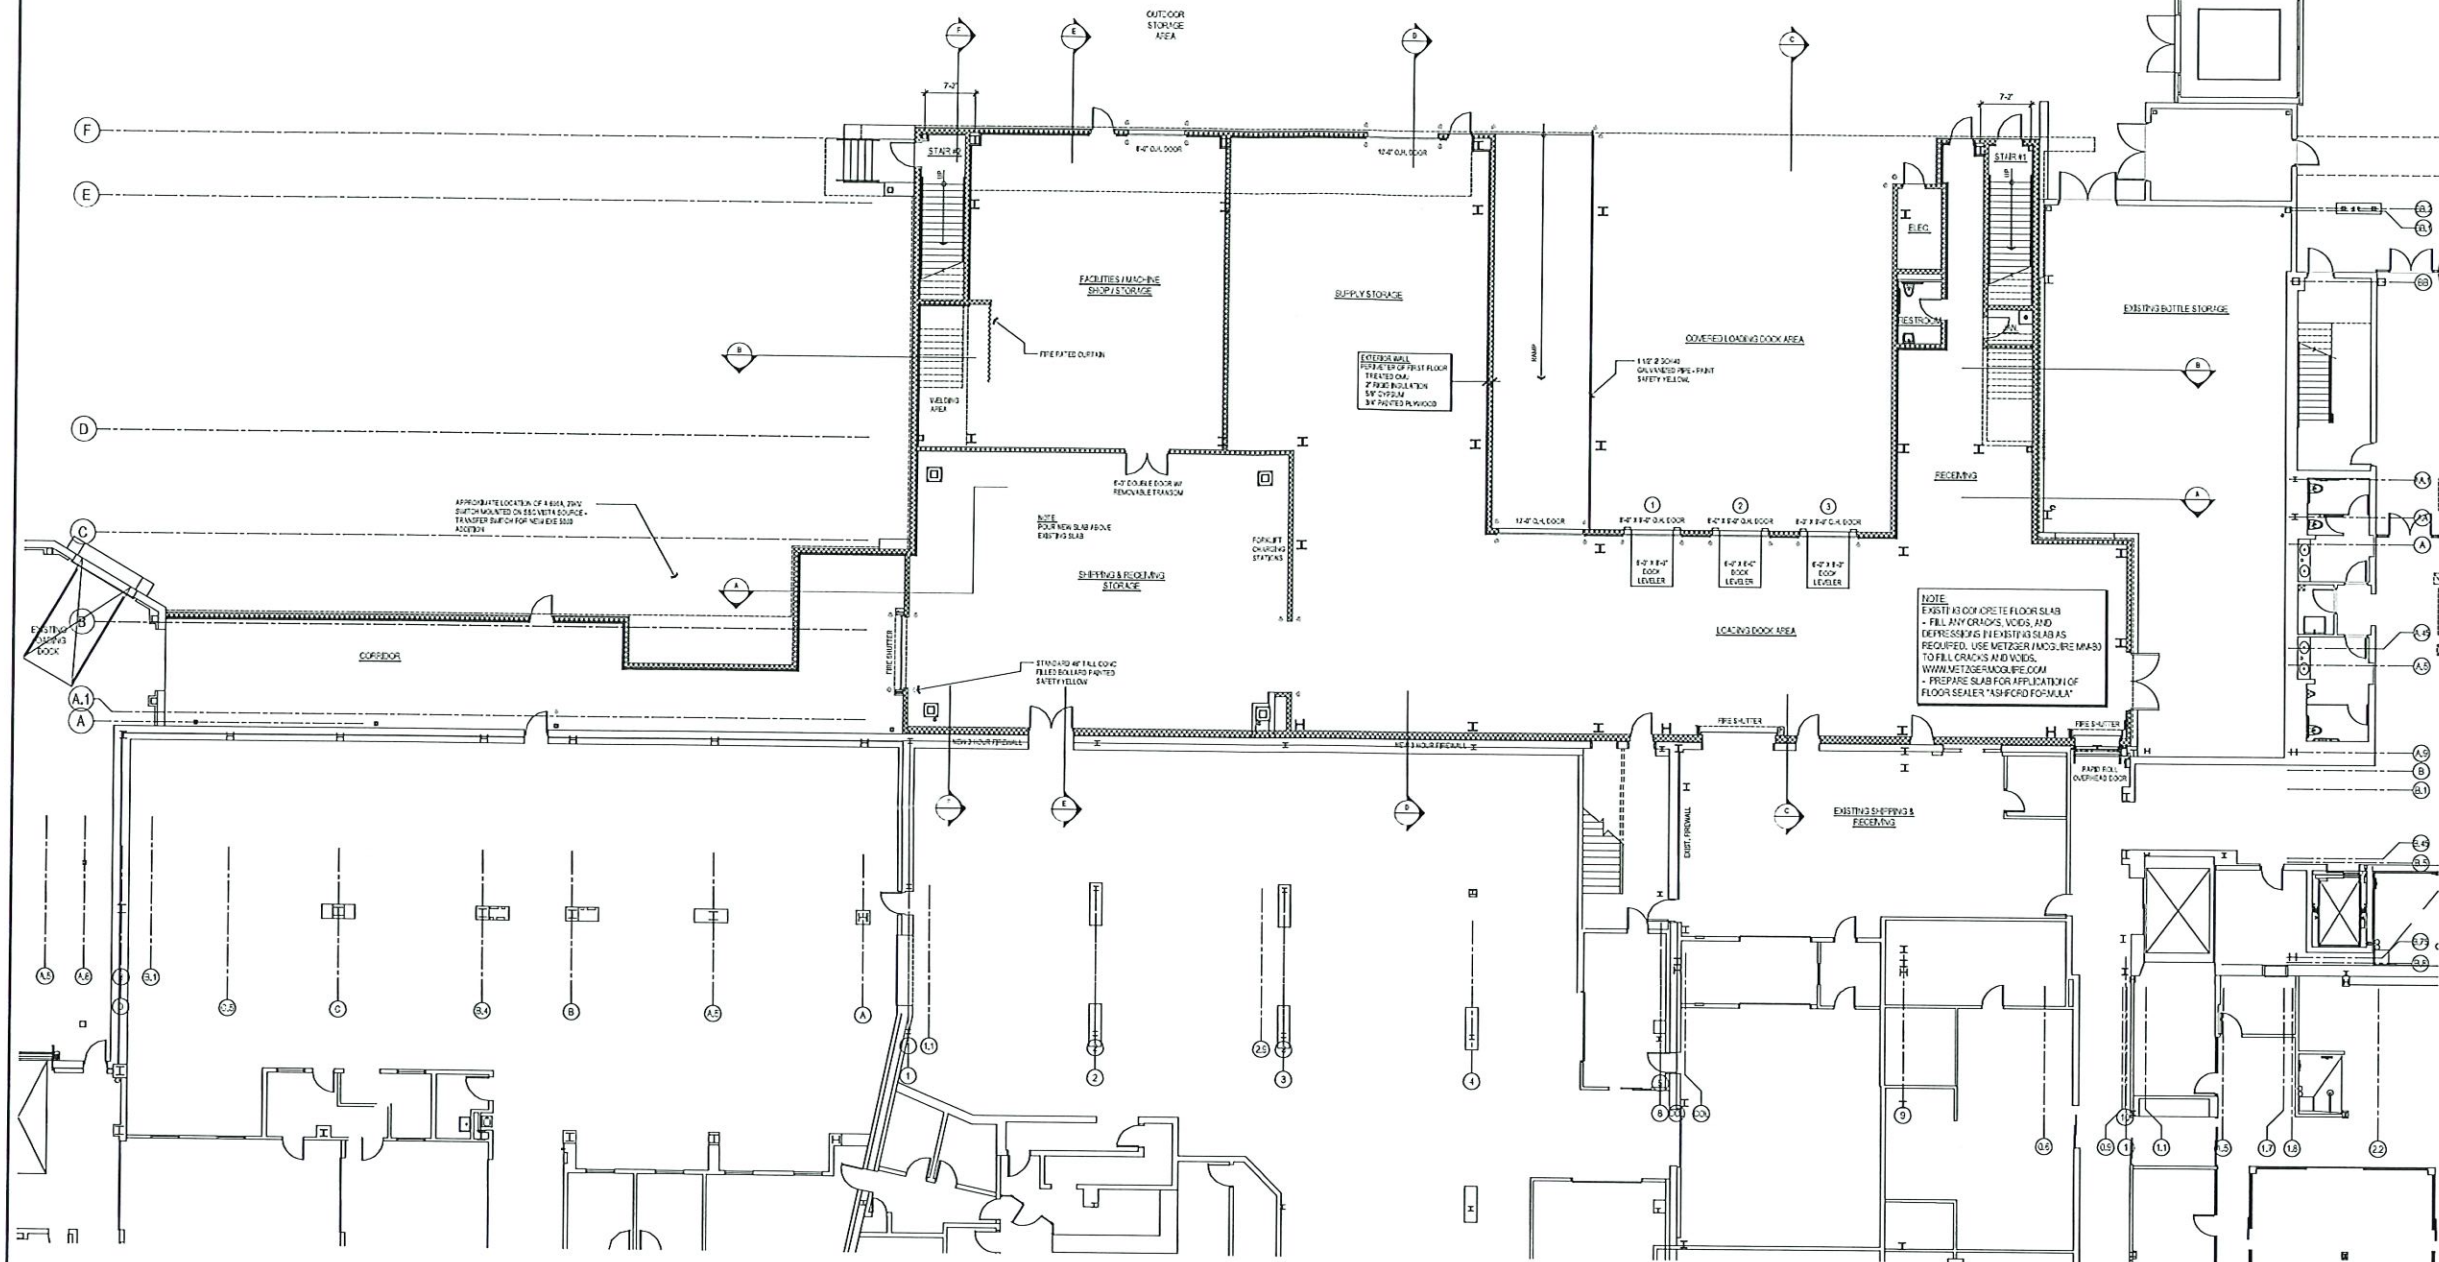

1 FIRST FLOOR PLAN
SCALE: 1/8" = 1'-0"

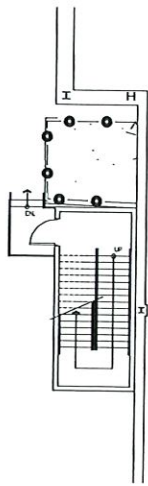

2 FIRST FLOOR EGRESS STAIR PLAN
SCALE: 1/8" = 1'-0"

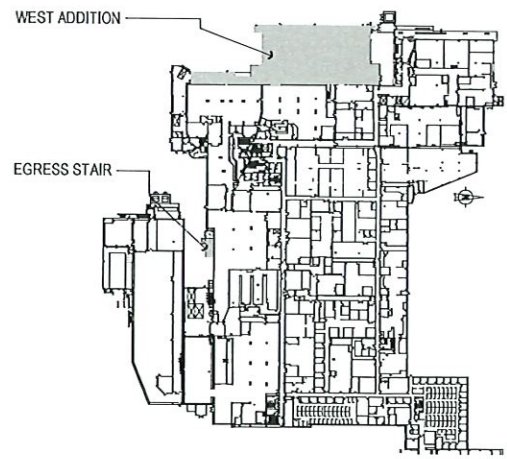

3 FIRST FLOOR KEY PLAN
N.T.S.


10/1/21	DESIGN DEVELOPMENT ISSUE
Issue & Revision List	
ASML Ref. No.	


ASML
77 DANBURY ROAD
WILTON, CT 06897
WEST ADDITION

Date	12.12.21	Drawn By	-
Scale	1/8" = 1'-0"	Approved By	S.Y.
Job No	210114	File	210114-01.dwg
Drawing Title:			
PROPOSED FIRST FLOOR PLAN			

COPYRIGHT:
All rights reserved. No part of this publication may be reproduced, stored in a retrieval system, or transmitted, in any form or by any means, electronic, mechanical, photocopying, recording, or by any information storage and retrieval system, without the prior written permission of the copyright owner.

 Drawing Number:
DSK601



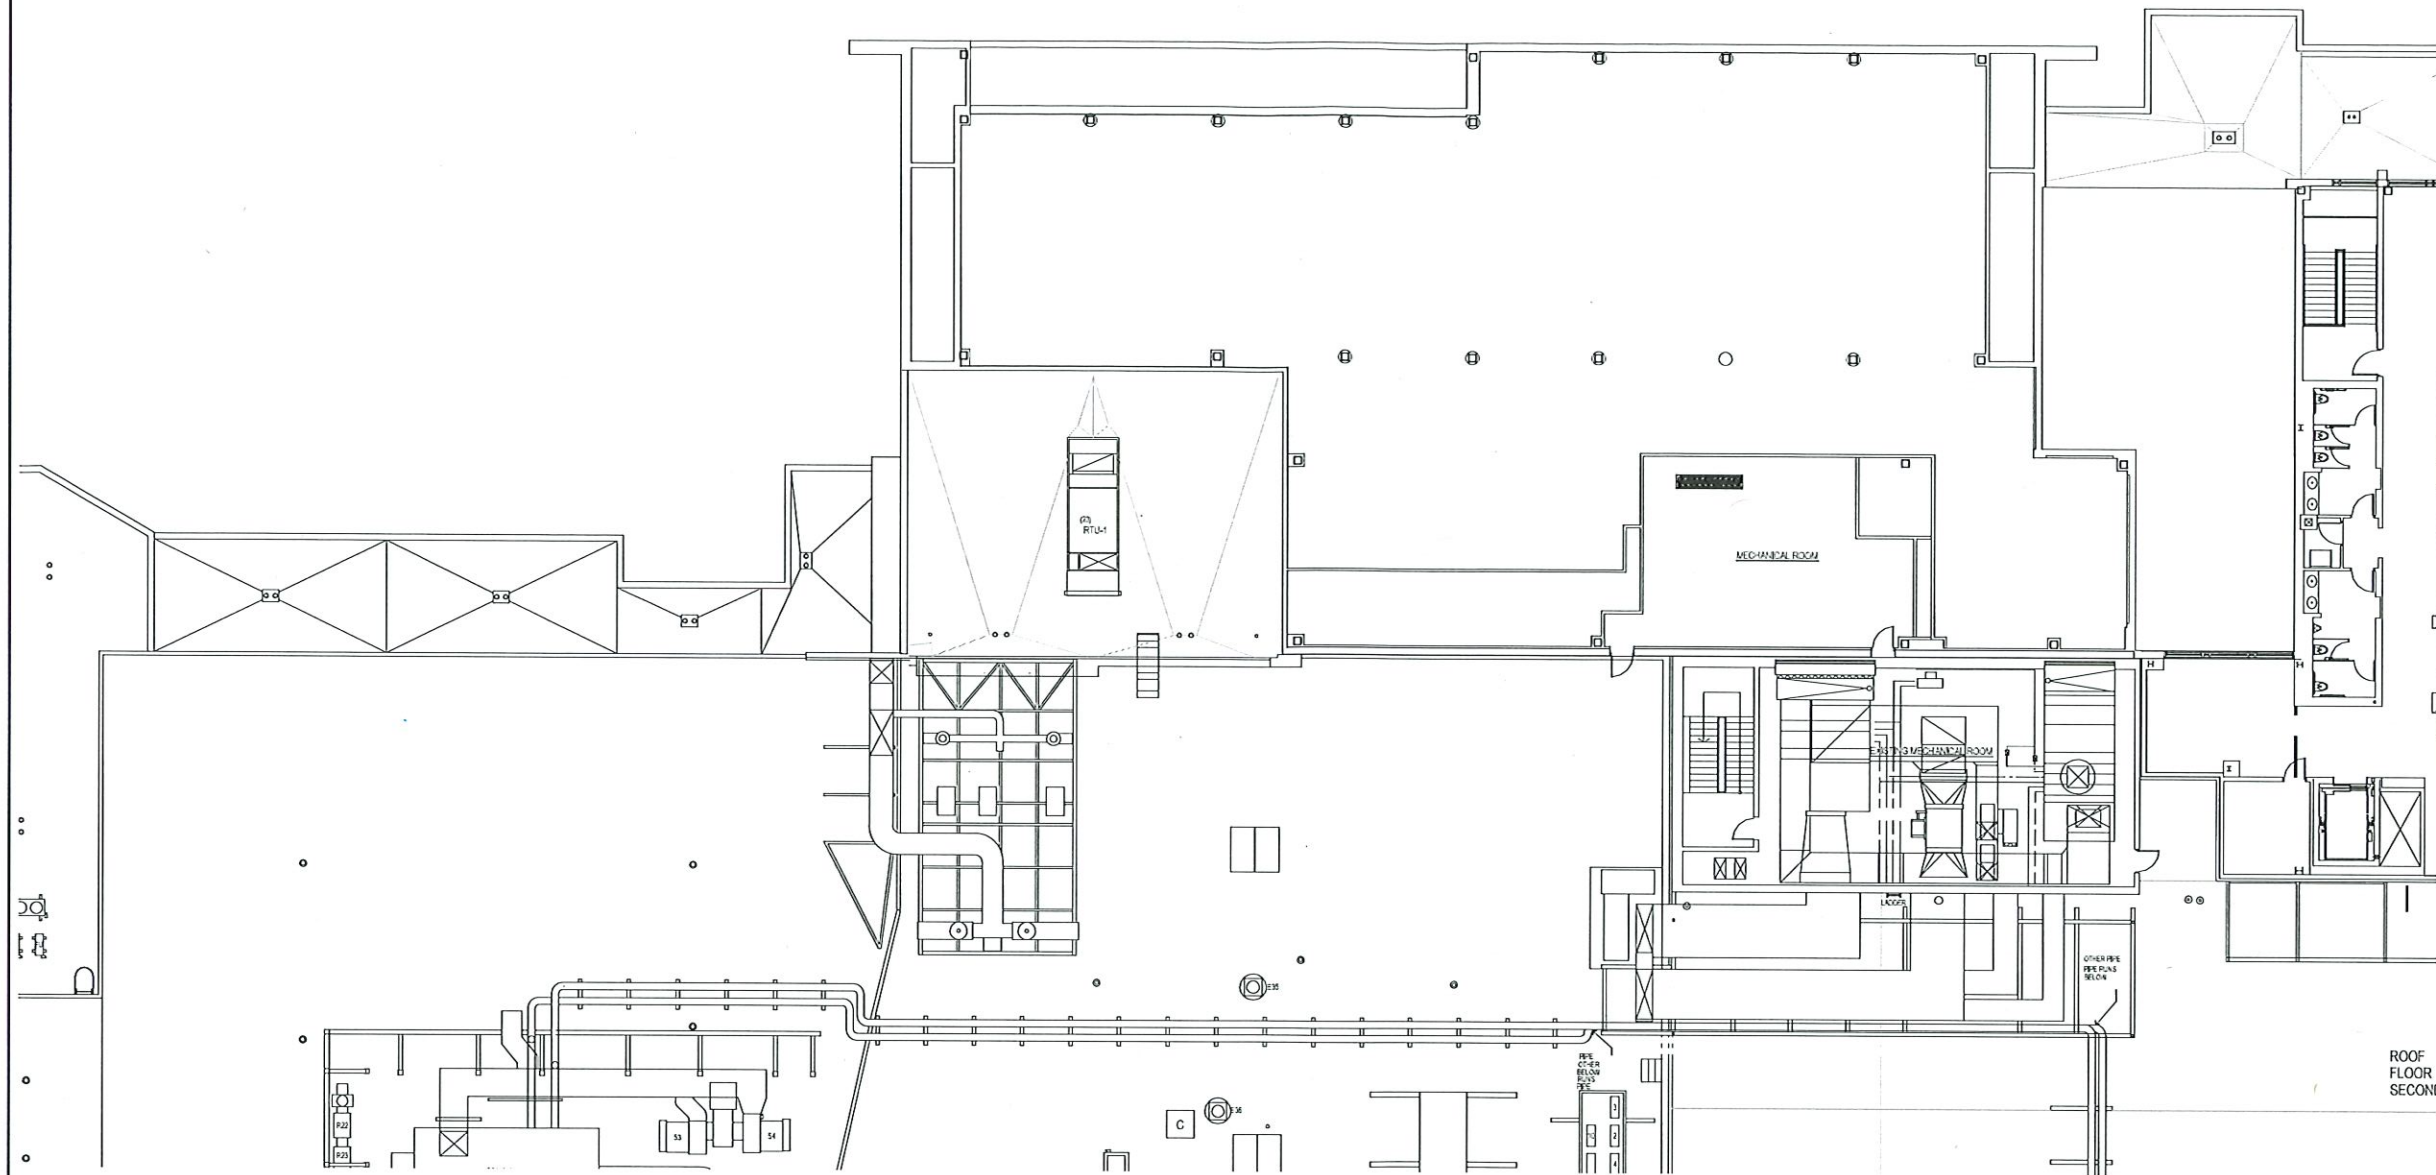

① THIRD FLOOR PLAN
SCALE: 1/8" = 1'-0"

12/15/21	DESIGN DEVELOPMENT ISSUE
Issue & Revision List	
ASML Ref. No.	

ASML

77 DANBURY ROAD
WILTON, CT 06897

WEST ADDITION

Date	12/15/21	Drawn By	-
Scale	1/8" = 1'-0"	Approved By	S.V.
Job No	21614	File	21614-03


Drawing Title:
PROPOSED THIRD FLOOR
PLAN

COPYRIGHT:
All rights reserved. No part of this drawing may be reproduced or transmitted in any form or by any means electronic or mechanical, including photocopying, recording, or by any information storage and retrieval system, without the prior written permission of H & R Design, Inc. This drawing is the property of H & R Design, Inc. and is to be used only for the project and location specified on the title block. Any other use is strictly prohibited.

Drawing Number:
DSK603

H & R DESIGN
FACILITIES
PLANNERS

LESSON
INDUSTRIES
PLANNING
31 GOSWOLD STREET, DANBURY, CT 06813
TEL 203-744-7700 FAX 203-744-6531

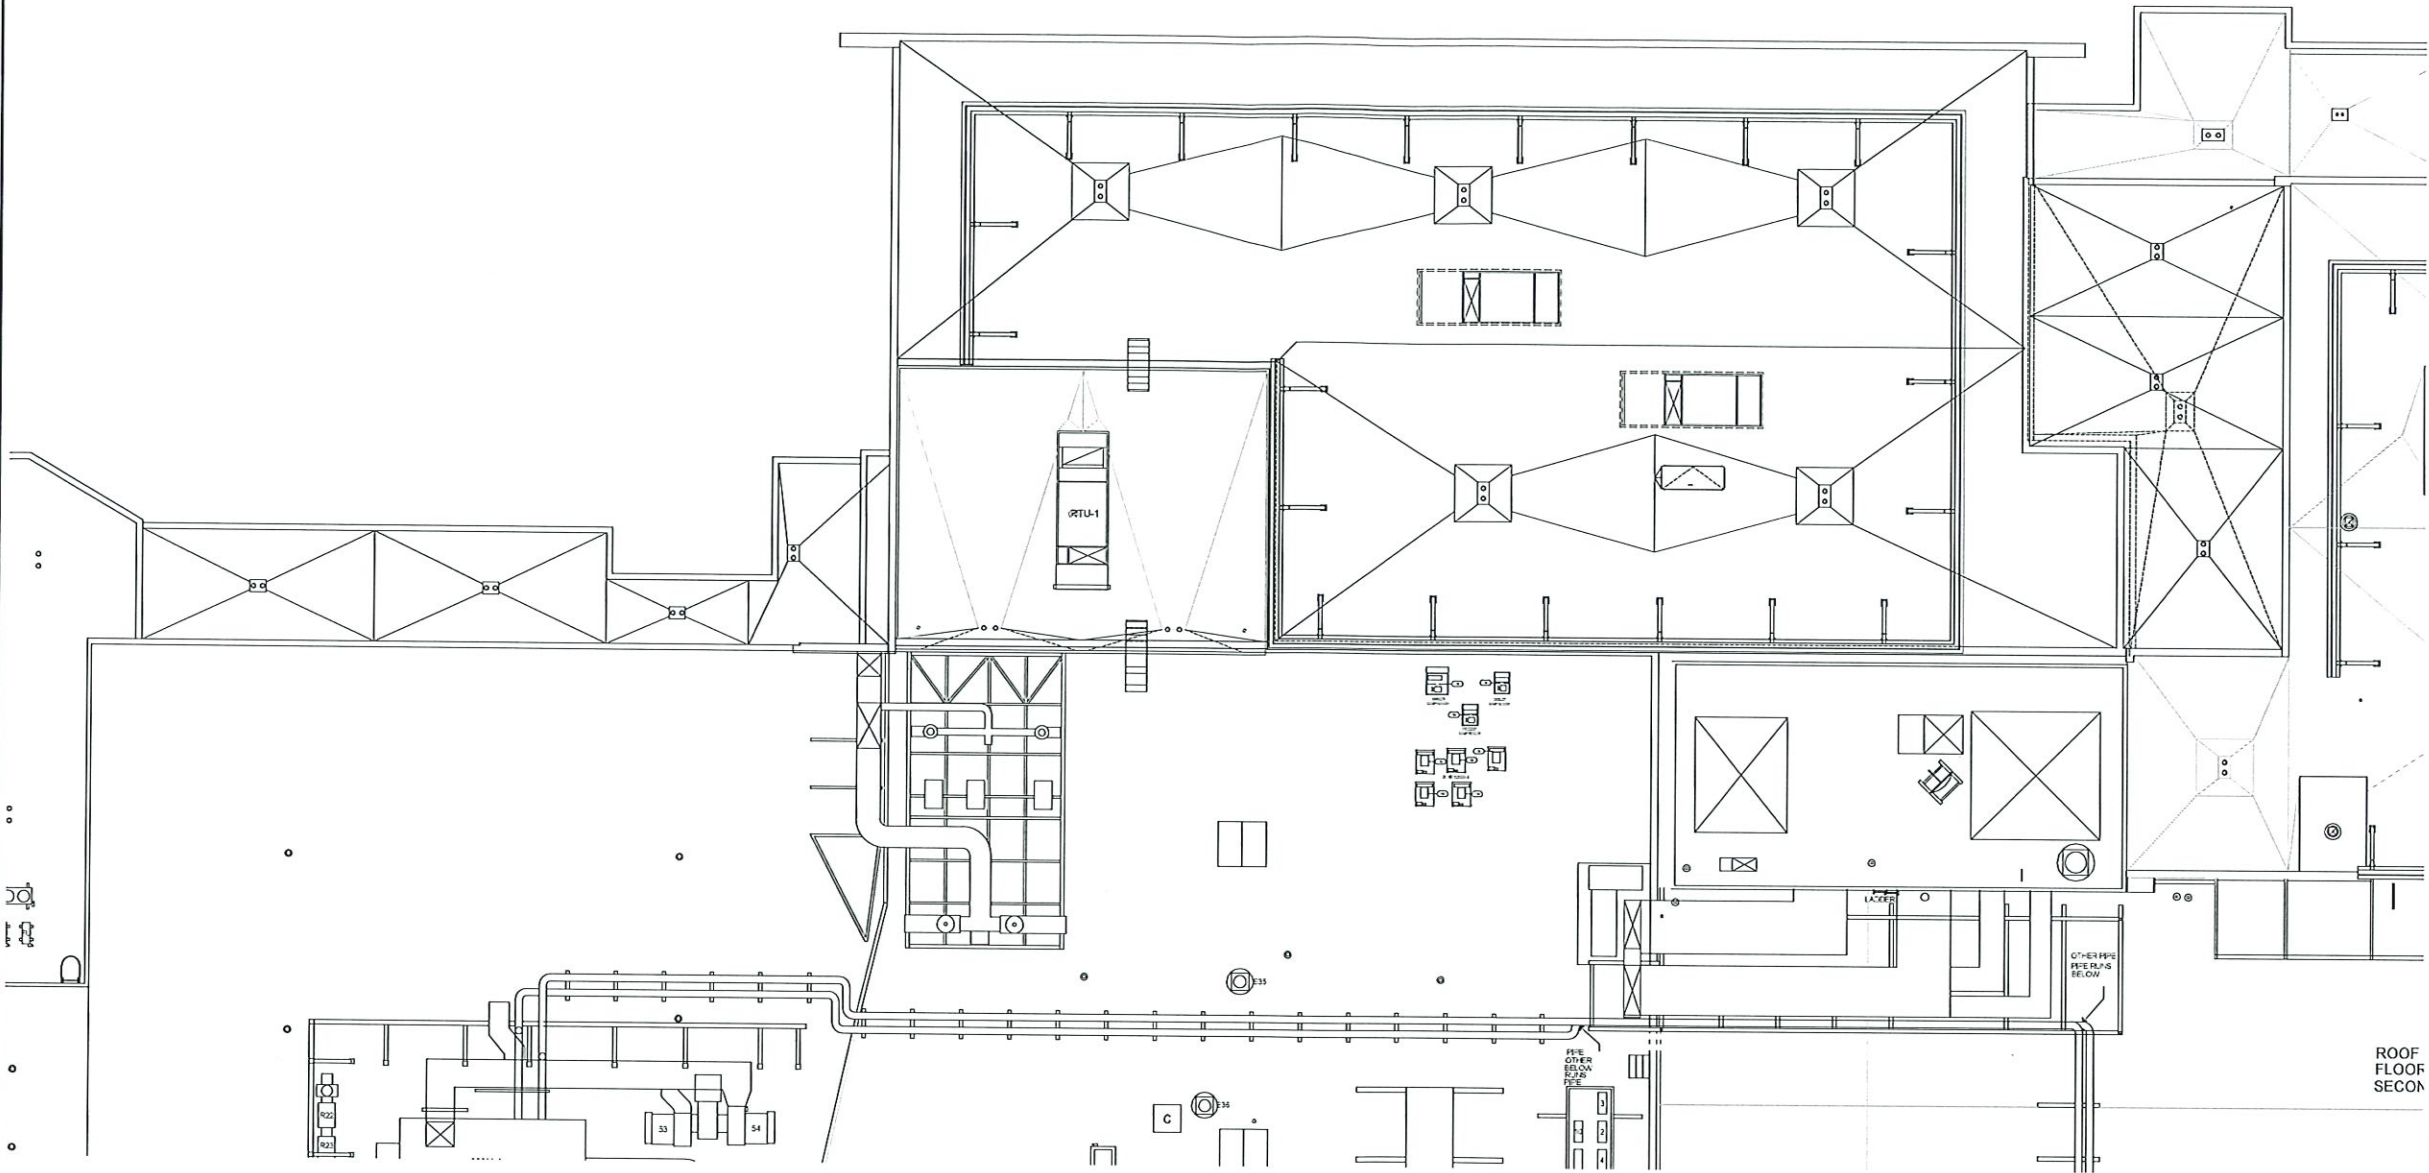

1 ROOF PLAN
SCALE: 1/8" = 1'-0"

ROOF
FLOOR
SECOND

10/12/21	DESIGN DEVELOPMENT ISSUE
Issue & Revision List	
ASML Ref. No.	

ASML

77 DANBURY ROAD
WILTON, CT 06897


WEST ADDITION

Date	10.10.21	Drawn By	
Scale	1/8" = 1'-0"	Approved By	S.Y.
Job No	210614	File	210614-01.dwg

Drawing Title:
PROPOSED ROOF PLAN

COPYRIGHT:
All rights reserved. No part of this drawing may be reproduced, stored in a retrieval system, or transmitted in any form or by any means, electronic, mechanical, photocopying, recording, or by any information storage and retrieval system, without the prior written permission of H&R Design, Inc. This drawing is the property of H&R Design, Inc. and is to be used only for the project and location specified on the title block. Any other use is strictly prohibited. H&R Design, Inc. reserves the right to make changes to this drawing at any time without notice.

Drawing Number:
DSK604

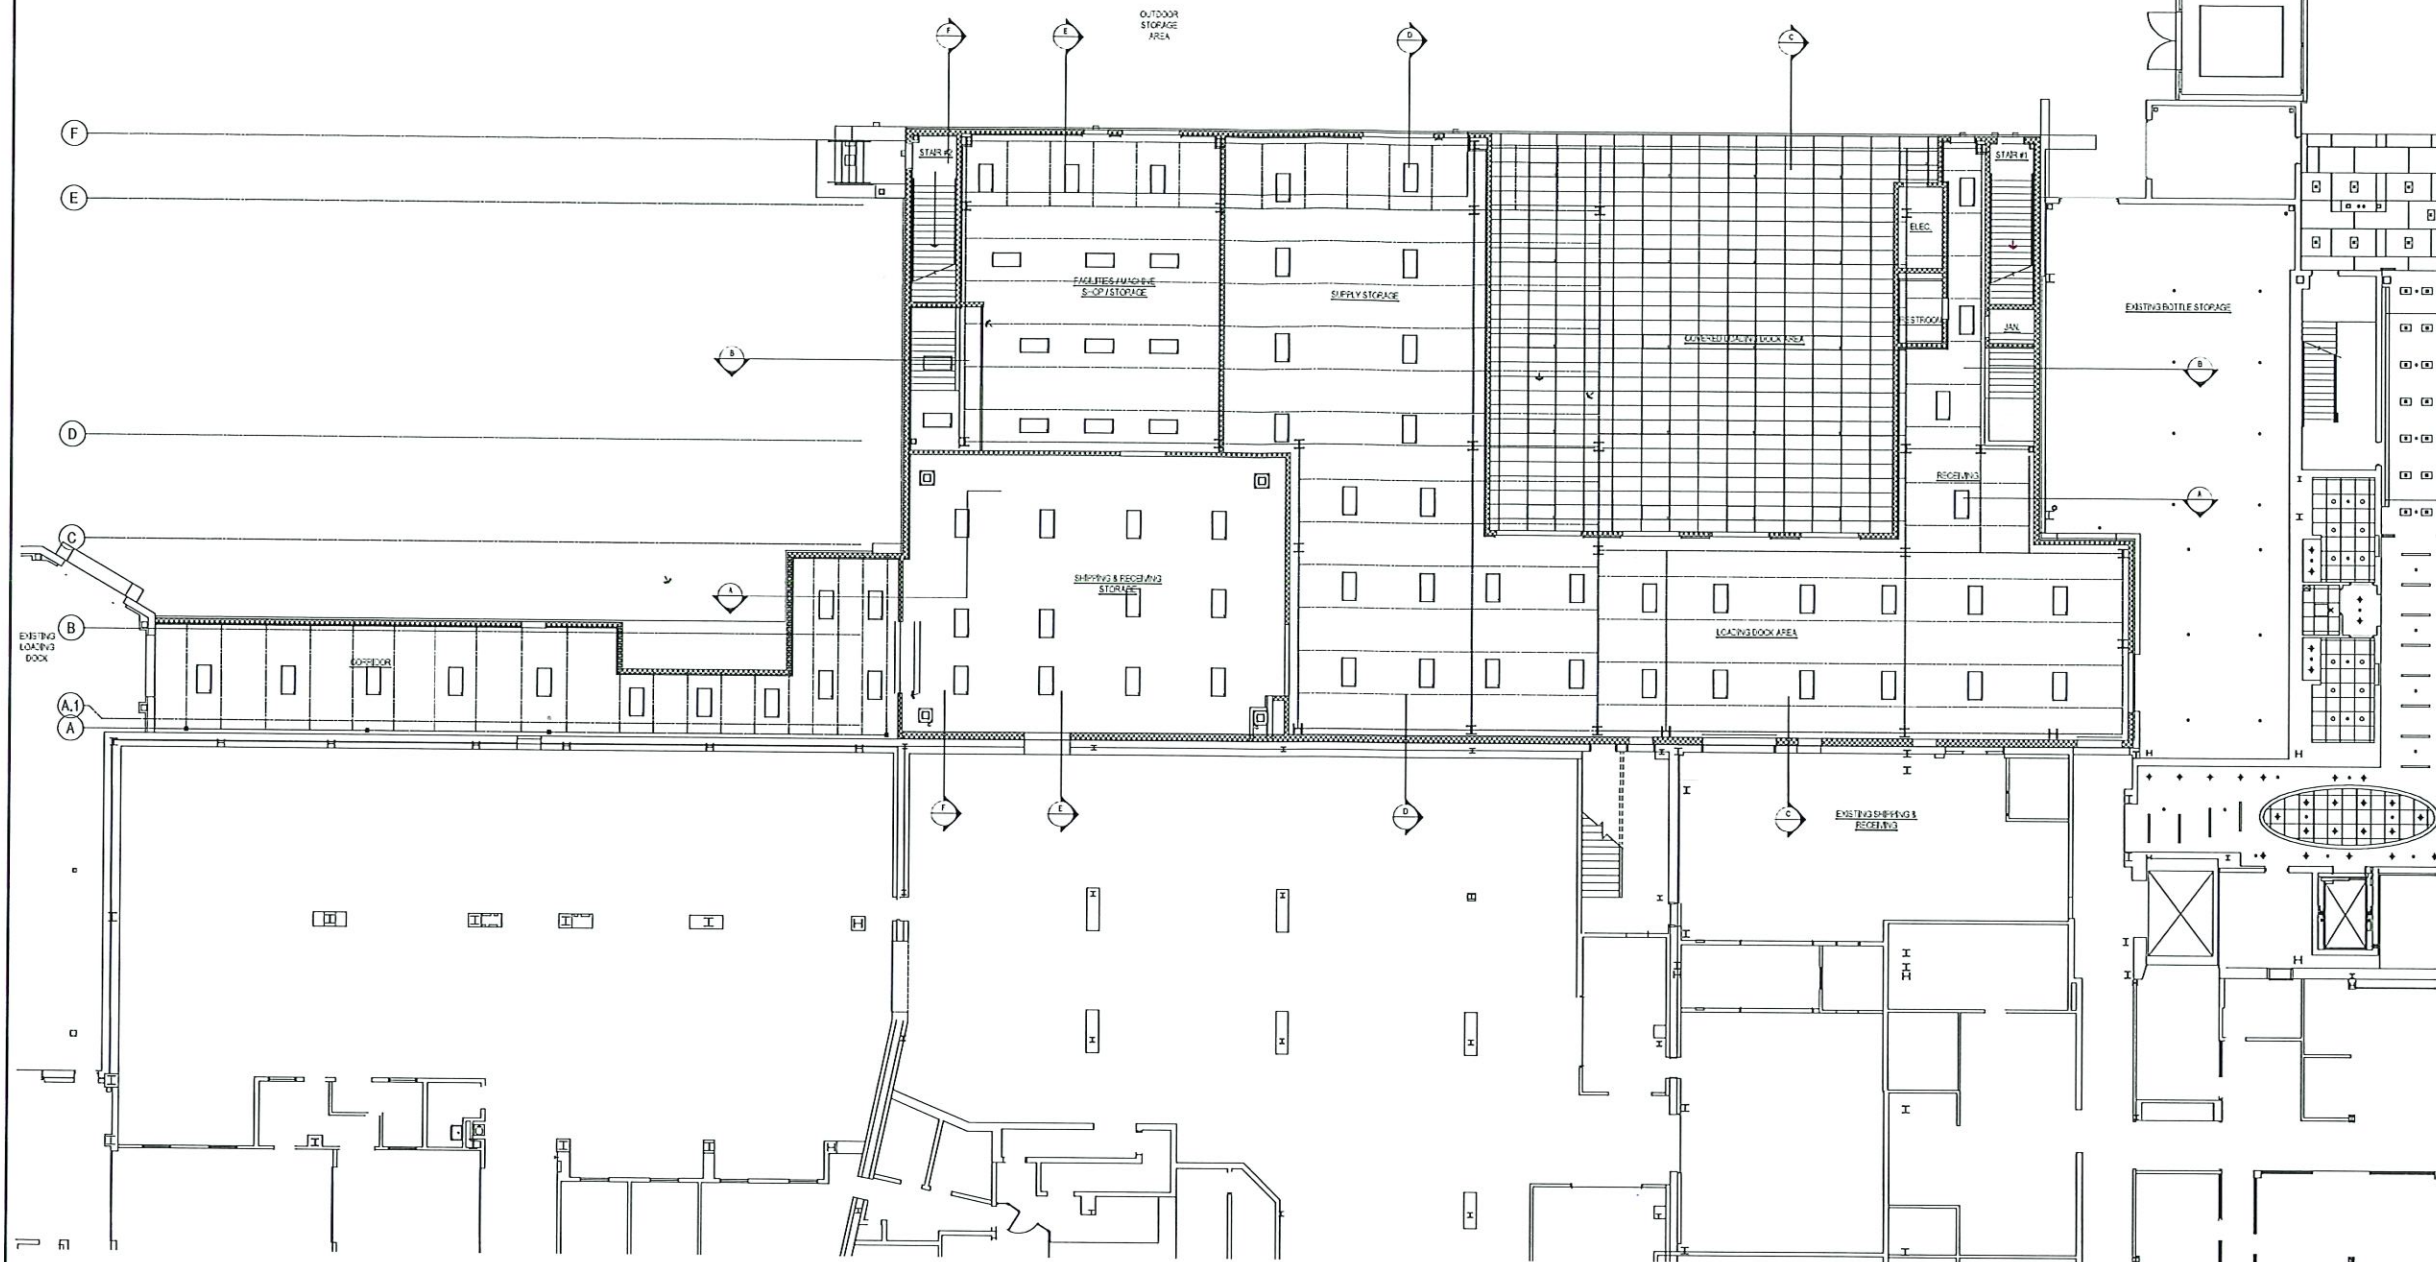

1 FIRST FLOOR REFLECTED CEILING PLAN
SCALE: 1/8" = 1'-0"

LIGHT FIXTURE SCHEDULE						
TYPE	DESCRIPTION	APPROVED MANUFACTURERS	MODEL NUMBER	LAMP	FIXTURE VAW	FIXTURE VOLTAGE
A	2'X4' HIGH-BAY LED LIGHT FIXTURE	LITHONIA	1B1ST			
B	2'X4' LED LIGHT FIXTURE	LITHONIA	2FSL4			
C	3" LED LOW-PROFILE FIXED DOWNLIGHT	ELEMENT	E3S			
D	4'X10' WALL RECESSED LUMINAIRE	LIGVAN	U43011			
E	EMERGENCY LED SCONCE	DUAL LITE	PG			
F	CROSSTOUR MAXX LED	LUMARK	XTOR3A			
REMARKS						

H & R DESIGN
FACILITIES
PLANNERS
DESIGN
INTERIORS
PLANNING
51 GEORGE STREET, DANBURY, CT 06813
PH 203-746-8770 FAX 203-746-8783

10/1/21 DESIGN DEVELOPMENT ISSUE
Issue & Revision List
ASML Ref. No.

ASML

77 DANBURY ROAD
WILTON, CT 06897


WEST ADDITION

Date 10/1/21 Drawn By S.V.
Scale 1/8" = 1'-0" Approved By S.V.
Job No 210514 File

Drawing Title:
PROPOSED FIRST FLOOR
REFLECTED CEILING PLAN

COPYRIGHT:
All Design and/or architectural drawings are the property of H & R Design, Inc. and shall remain the property of H & R Design, Inc. until such time as they are released to the client. No part of this drawing may be reproduced or transmitted in any form or by any means electronic or mechanical, including photocopying, recording, or by any information storage and retrieval system, without the prior written permission of H & R Design, Inc.

Drawing Number:
DSK605

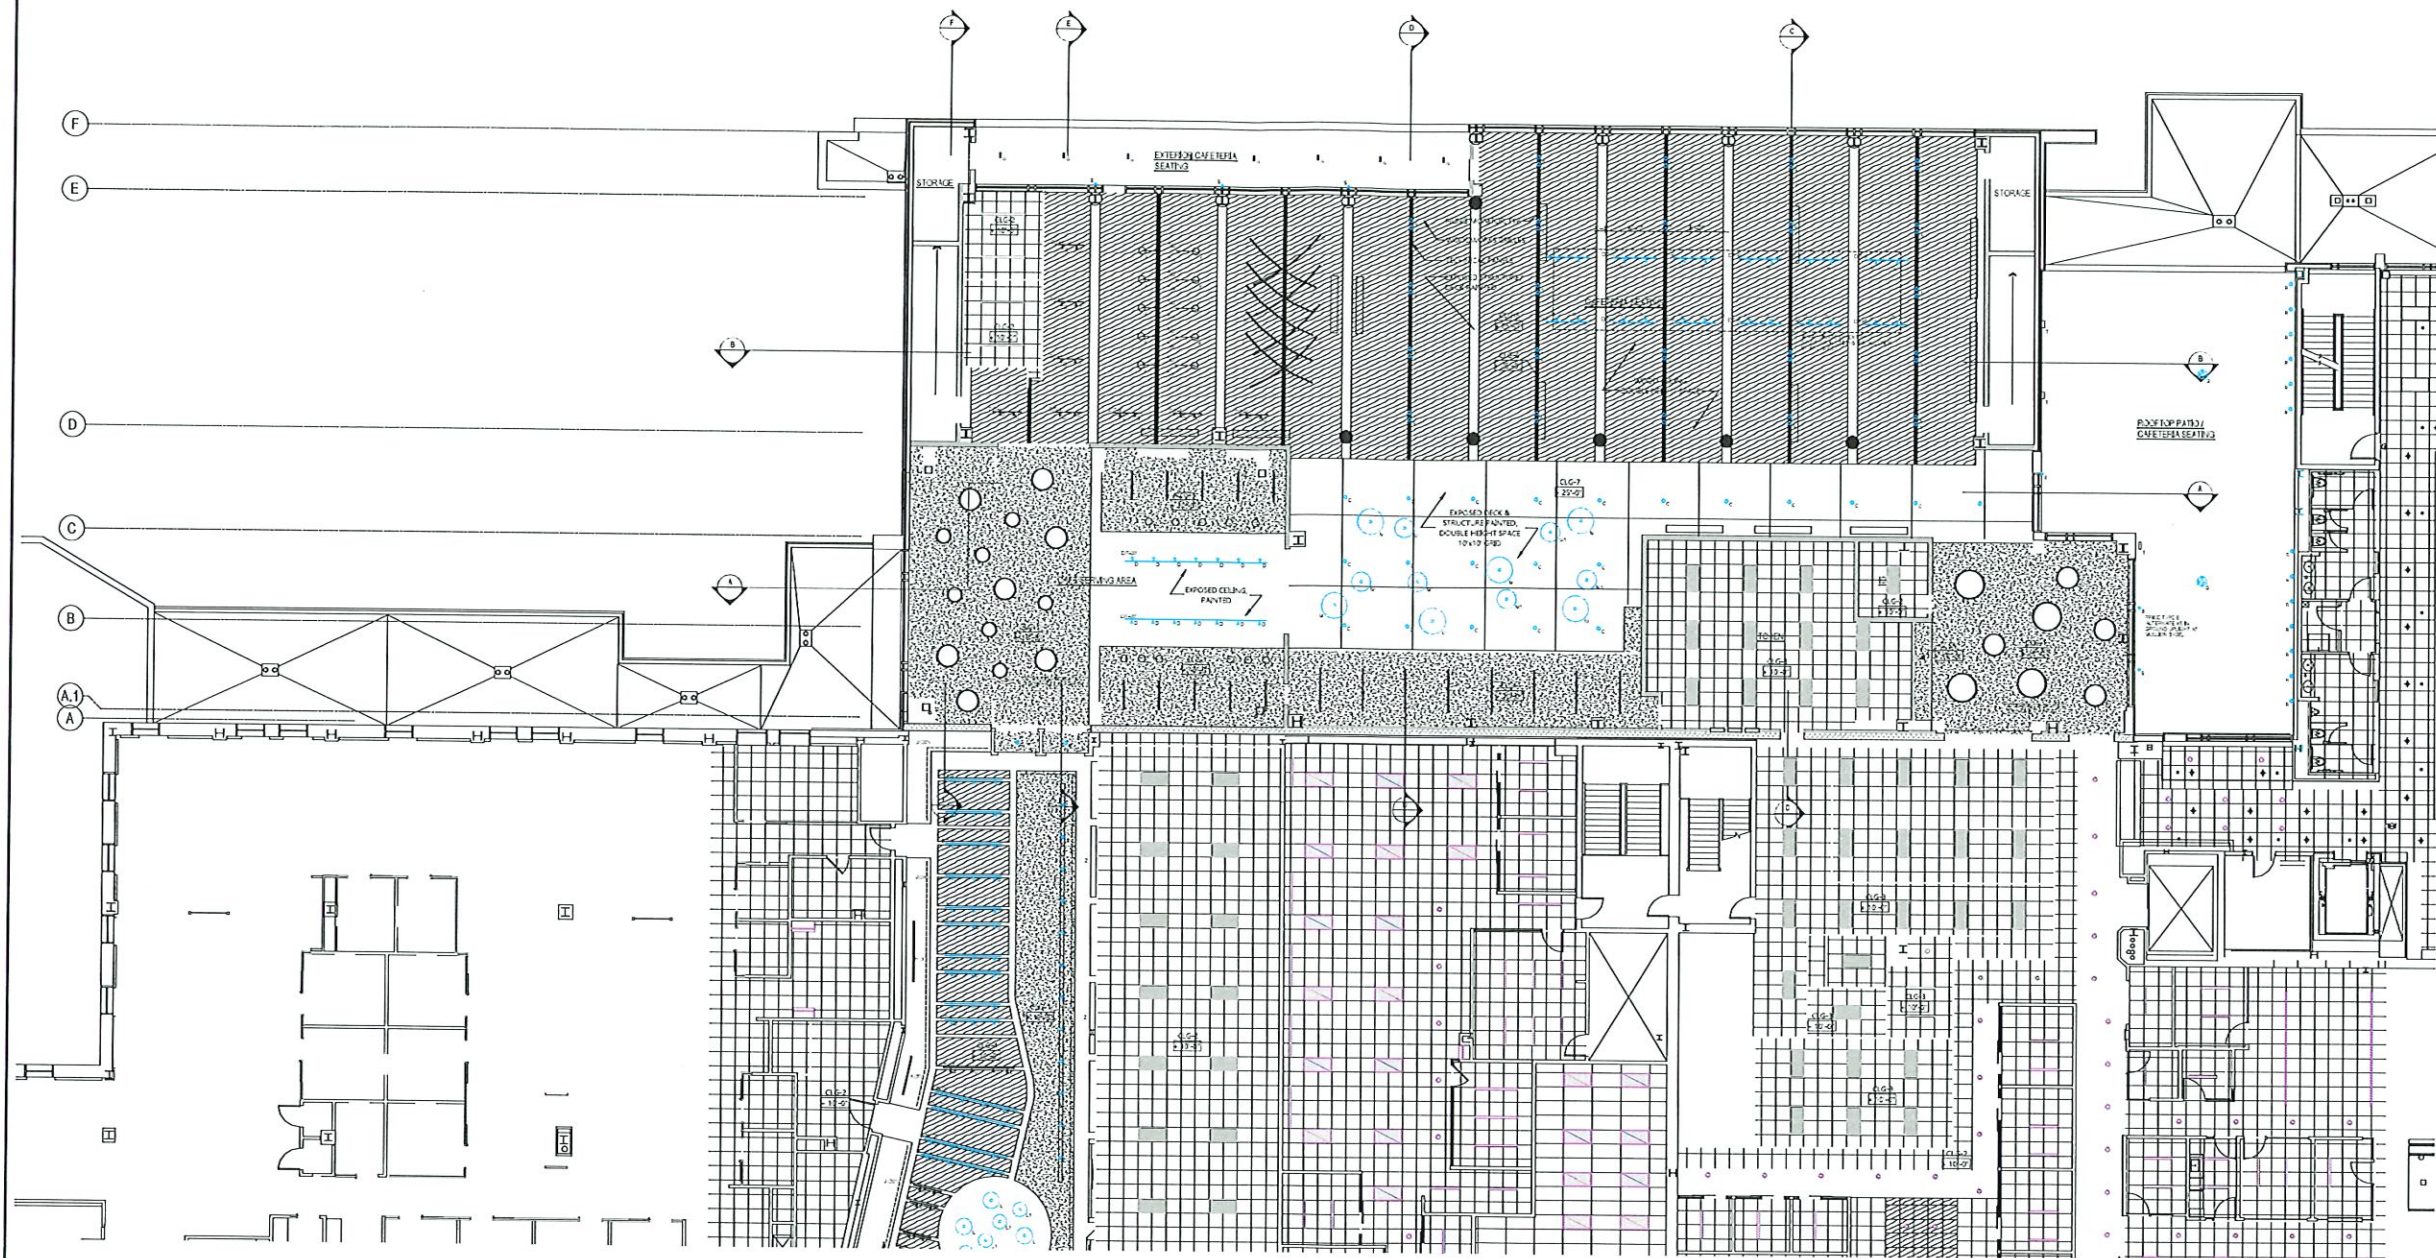

H & R DESIGN
FACILITIES
PLANNERS
LENN
INTERIORS
HANNUM
51 OSBORNE STREET, DANBURY, CT 06813
PH 203-794-1750 FAX 203-794-6813

10/13/21 DESIGN DEVELOPMENT ISSUE
Issue & Revision List
ASML Ref. 102

ASML
77 DANBURY ROAD
WILTON, CT 06897
WEST ADDITION

Date: 10/13/21 Drawn By: -
Scale: 1/8" = 1'-0" Approved By: S.Y.
Job No: 210514 File: -
Drawing Title:
PROPOSED SECOND
FLOOR REFLECTED
CEILING PLAN

COPYRIGHT:
© 2021 H & R DESIGN, INC. All rights reserved. No part of this document may be reproduced or transmitted in any form or by any means electronic or mechanical, including photocopying, recording, or by any information storage and retrieval system, without written permission from H & R DESIGN, INC. This document is the property of H & R DESIGN, INC. and is loaned to the client for their use only. It is not to be distributed outside the client's organization. H & R DESIGN, INC. is not responsible for any errors or omissions in this document.

Drawing Number:
DSK606



ROOF
FLOOR
SECOND

	12.19.21	DESIGN DE-ASSIGNMENT 12.19.21
--	----------	-------------------------------

Issue & Revision List
ASV, Ref. No.

ASML

77 DANBURY ROAD
WILTON, CT 06897

WEST ADDITION


Date	10.19.21	Drawn By
Scale	1/8" = 1'-0"	Approved By
Job No	21014	File

Drawing Title:
PROPOSED THIRD FLOOR
REFLECTED CEILING PLAN

COPYRIGHT:

[illegible]

Drawing Number:
DSK607

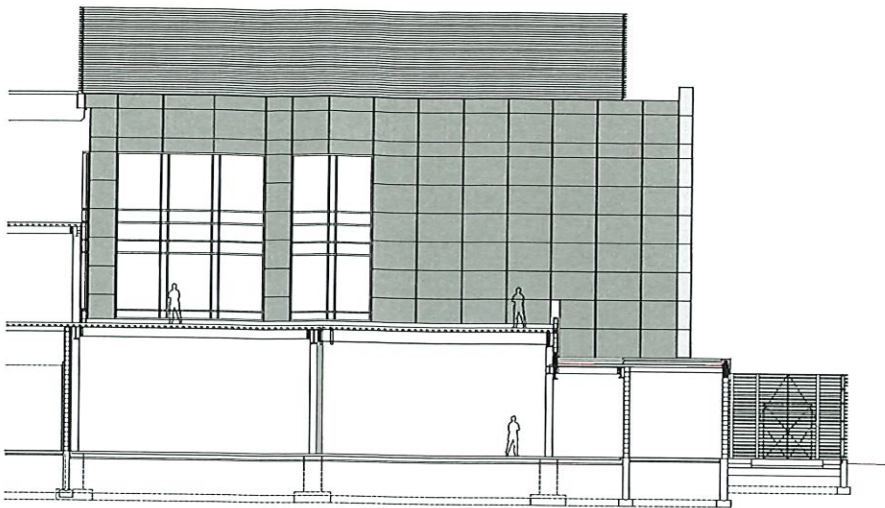

1 NORTH ELEVATION
SCALE: 1/8" = 1'-0"

11/13/21	DESIGN DEVELOPMENT ISSUE
Issue & Revision List	
ASML Ref No.	


ASML
77 DANBURY ROAD
WILTON, CT 06897
WEST ADDITION

Date	11.13.21	Drawn By	-
Scale		Approved By	S.Y.
Jac No	210114	File	

Drawing Title:
NORTH ELEVATION

COPYRIGHT:
© 2021 ASML Corporation. All rights reserved. This document is the property of ASML Corporation and is intended for internal use only. It is not to be distributed outside of ASML Corporation without the express written permission of ASML Corporation. Any unauthorized use or distribution of this document is strictly prohibited and may result in legal action.

Drawing Number:
DSK611

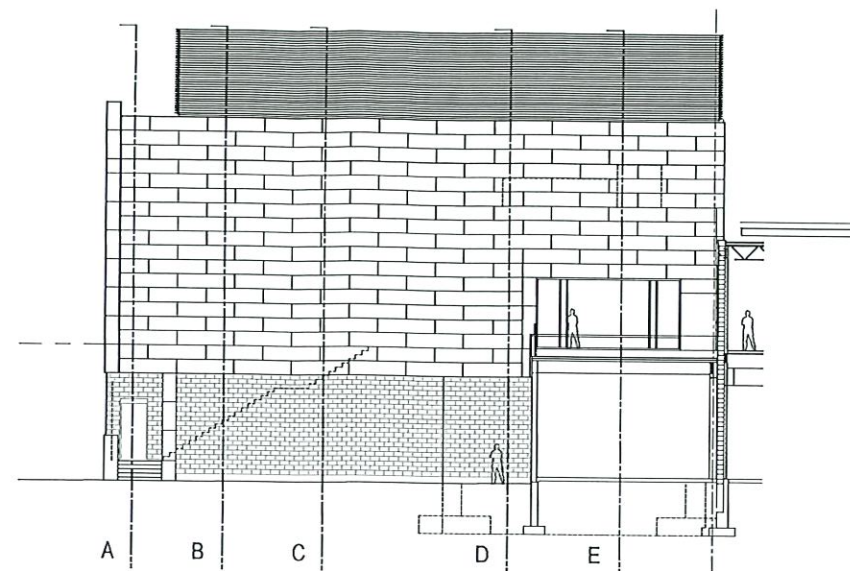

SOUTH ELEVATION
SCALE: 1/8" = 1'-0"

H & R DESIGN
FACILITIES
PLANNERS
DESIGN
INTERIORS
PLANNING
50 GEDDING STREET, DANBURY, CT 06811
PH: 203-668-1111 FAX: 203-668-1111

10.18.21 DESIGN DEVELOPMENT ISSUE
Issue & Revision List
ASML Ref. No.

ASML
77 DANBURY ROAD
WILTON, CT 06897

WEST ADDITION

Date: 10.18.21 Drawn By: S.Y.
Scale: Approved By: S.Y.
Job No: 210614 File:


Drawing Title:
SOUTH ELEVATION

COPYRIGHT:
All rights reserved. No part of this publication may be reproduced, stored in a retrieval system, or transmitted, in any form or by any means, electronic, mechanical, photocopying, recording, or by any information storage and retrieval system, without the prior written permission of the copyright owner.

Drawing Number:
DSK612

H & R DESIGN
FACILITIES
PLANNERS

LESSON
INTERIORS
PLANNING
51 GORDON STREET, DANBURY, CT 06813
PH 203-799-9150 FAX 203-799-5013

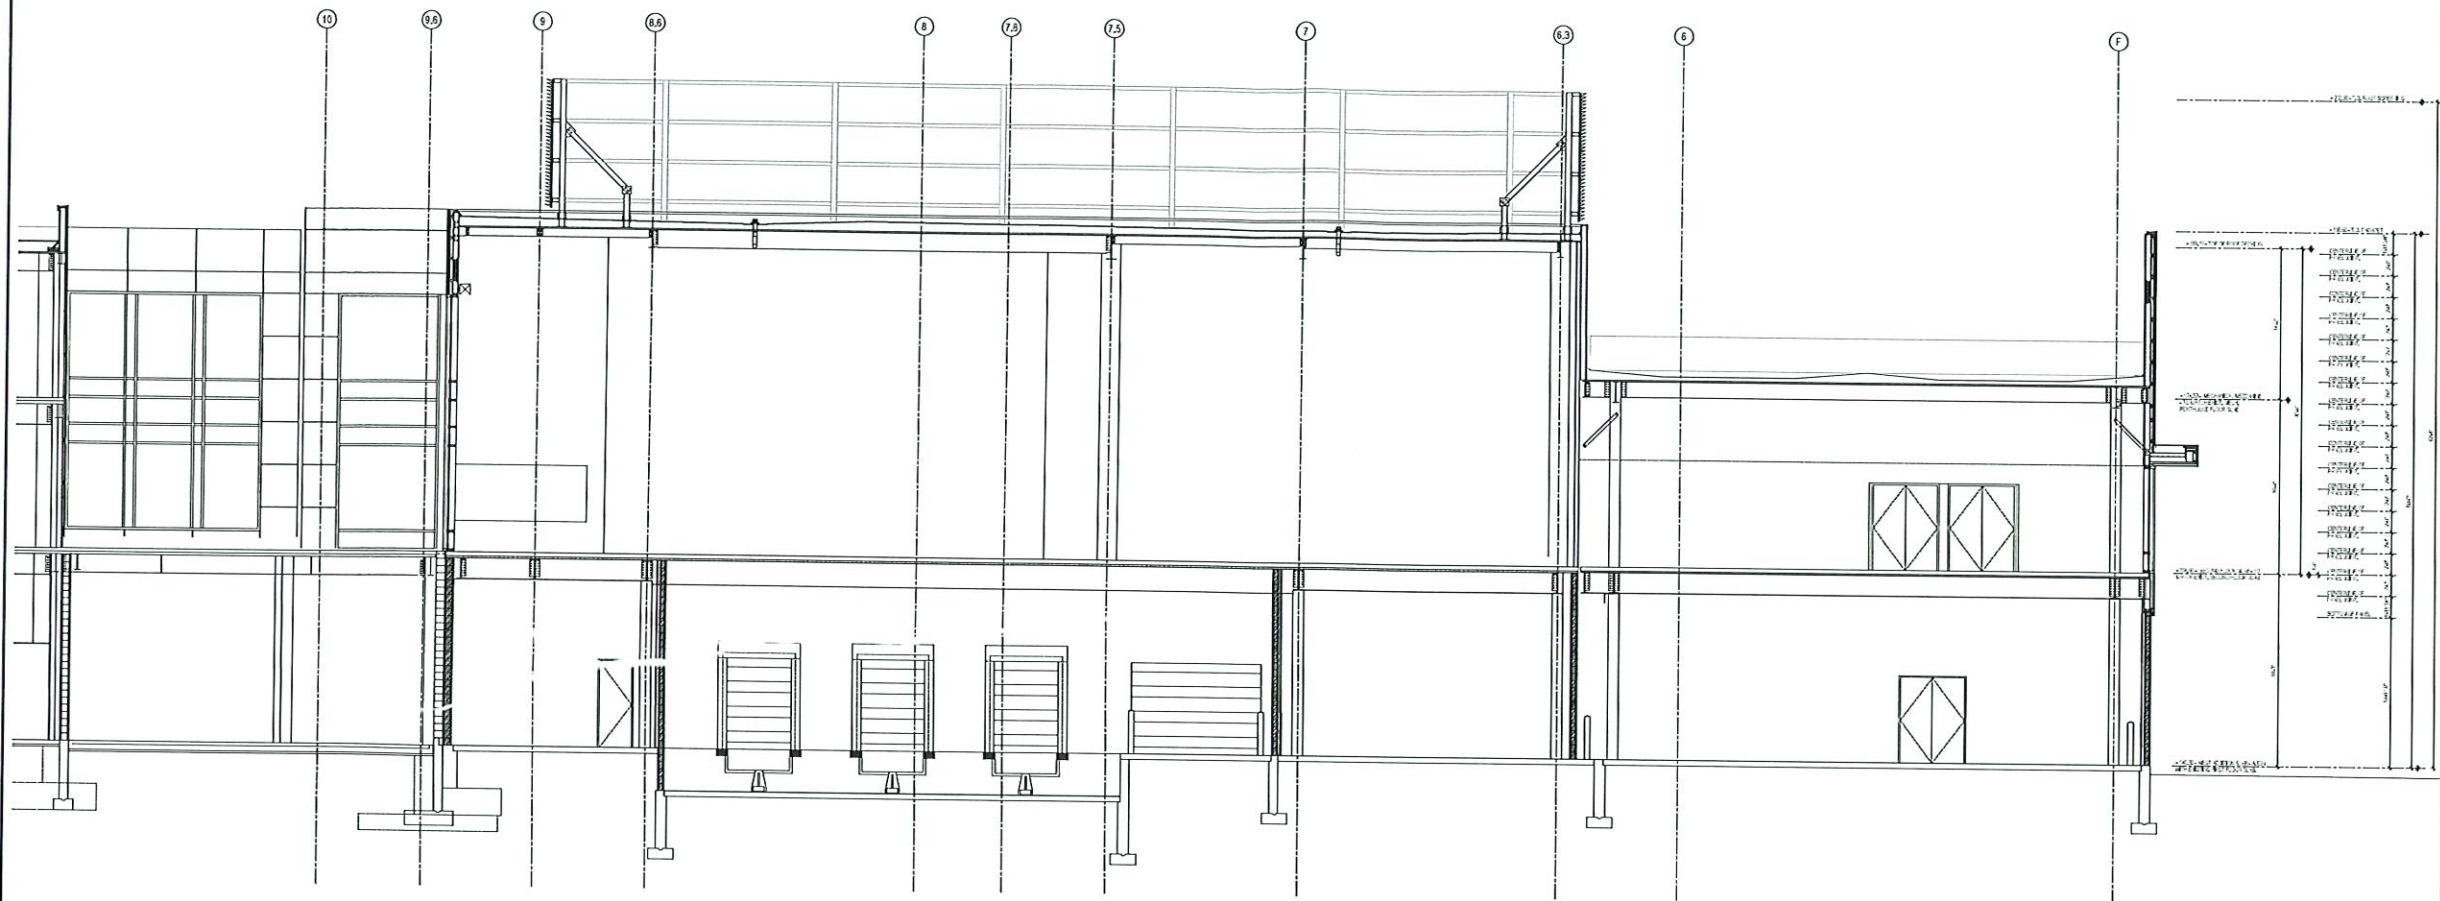

A BUILDING SECTION A
SCALE: 3/16" = 1'-0"

10/15/21 DESIGN DEVELOPMENT ISSUE

Issue & Revision List

ASML Ref. No.

ASML

77 DANBURY ROAD
WILTON, CT 06897

WEST ADDITION

Date 10.15.21 Drawn By

Scale 3/16" = 1'-0" Approved By S.Y.


Jac. No. 210114 File

Drawing Title:
BUILDING SECTION A

COPYRIGHT:

All rights reserved. No part of this drawing may be reproduced or transmitted in any form or by any means electronic or mechanical, including photocopying, recording, or by any information storage or retrieval system, without the written permission of H&R Design, Inc. This drawing is the property of H&R Design, Inc. and is loaned to the client for the project only. It is not to be used for any other project without the written permission of H&R Design, Inc.

Drawing Number:
DSK615

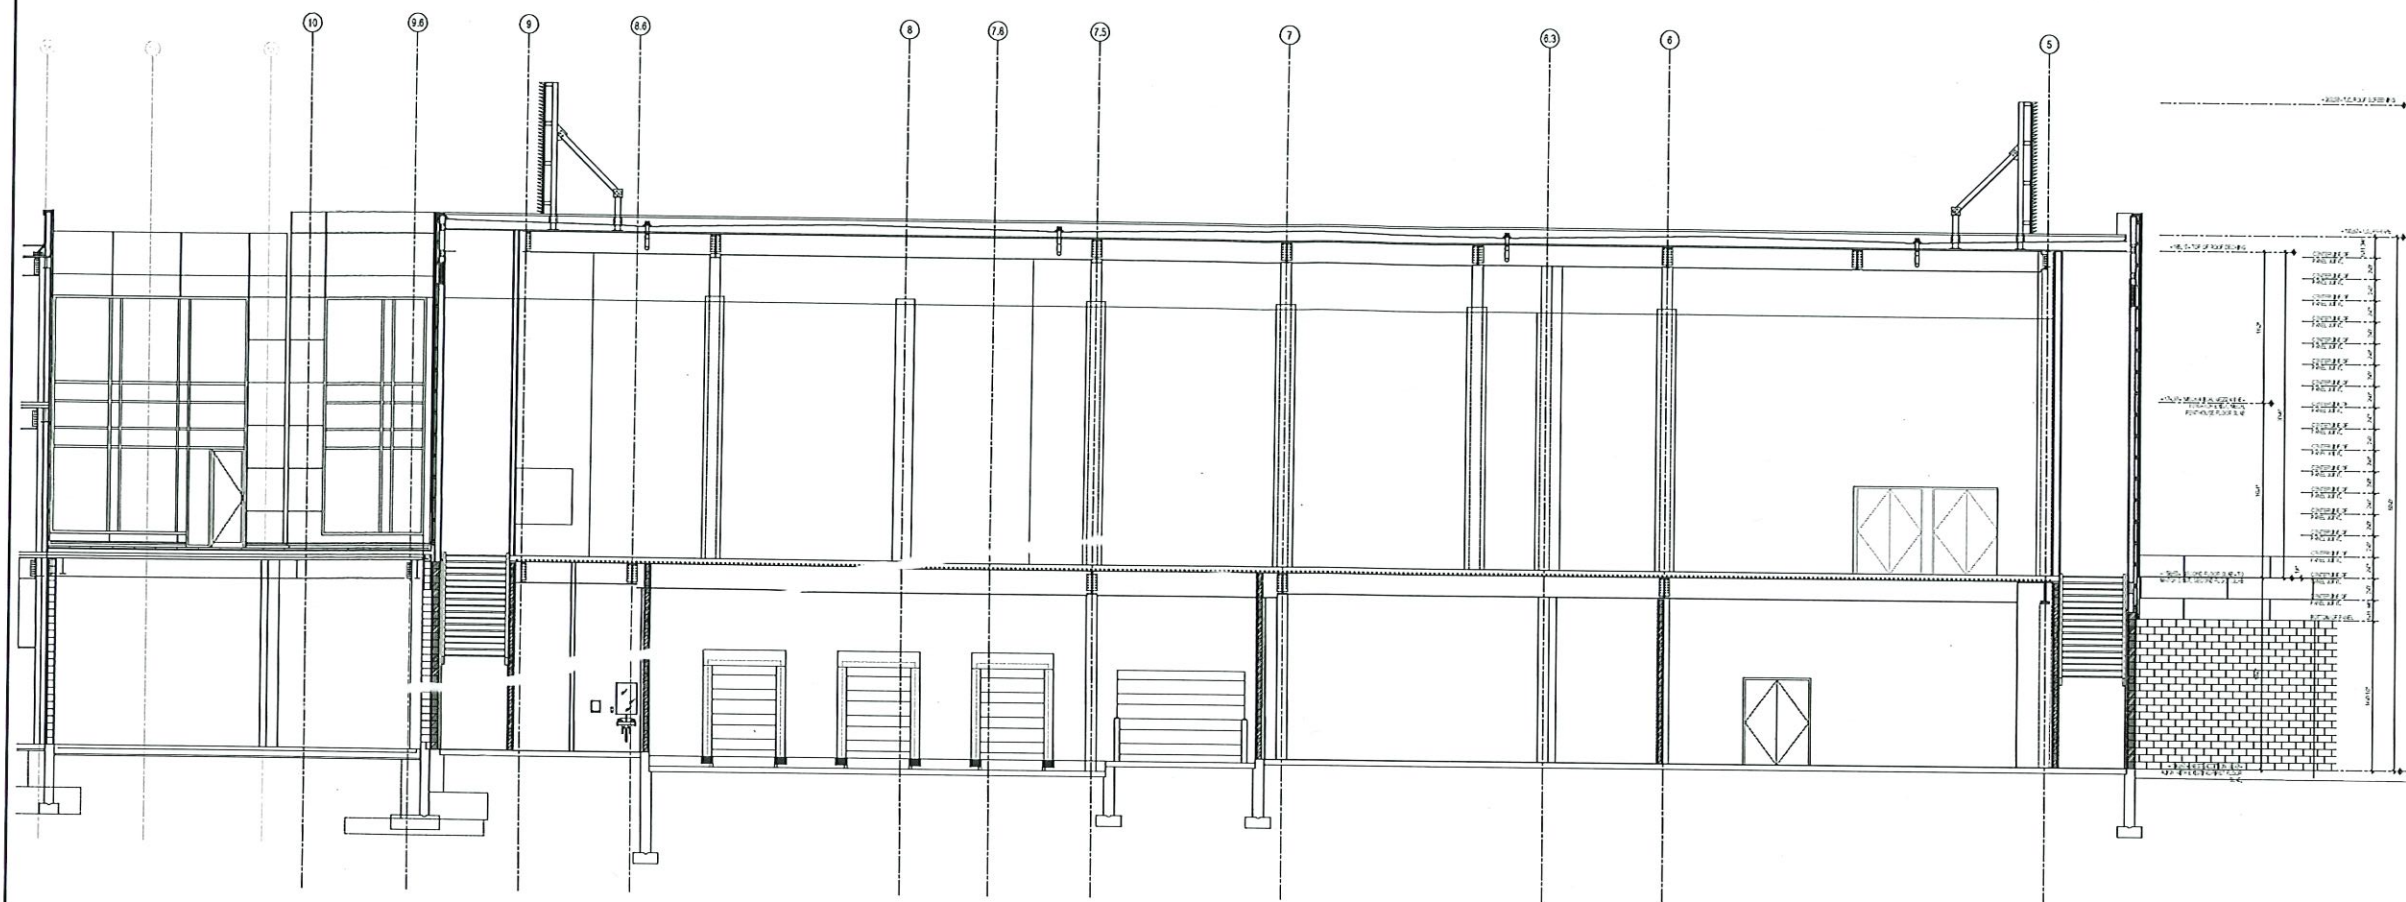

B BUILDING SECTION B
SCALE: 3/16" = 1'-0"

11/10/21 DESIGN DEVELOPMENT ISSUE
Issue & Revision List:
ASML Ref. No.

ASML

77 DANBURY ROAD
WILTON, CT 06897


WEST ADDITION

Date: 11.18.21 Drawn By: -
Scale: 3/16" = 1'-0" Approved By: S.Y.
Juc. No: 21014 Filed: 11/18/21


Drawing Title:
BUILDING SECTION B

COPYRIGHT:
All rights reserved. No part of this drawing may be reproduced or transmitted in any form or by any means electronic or mechanical, including photocopying, recording, or by any information storage and retrieval system, without the prior written permission of H&R Design, Inc.

Drawing Number:
DSK616

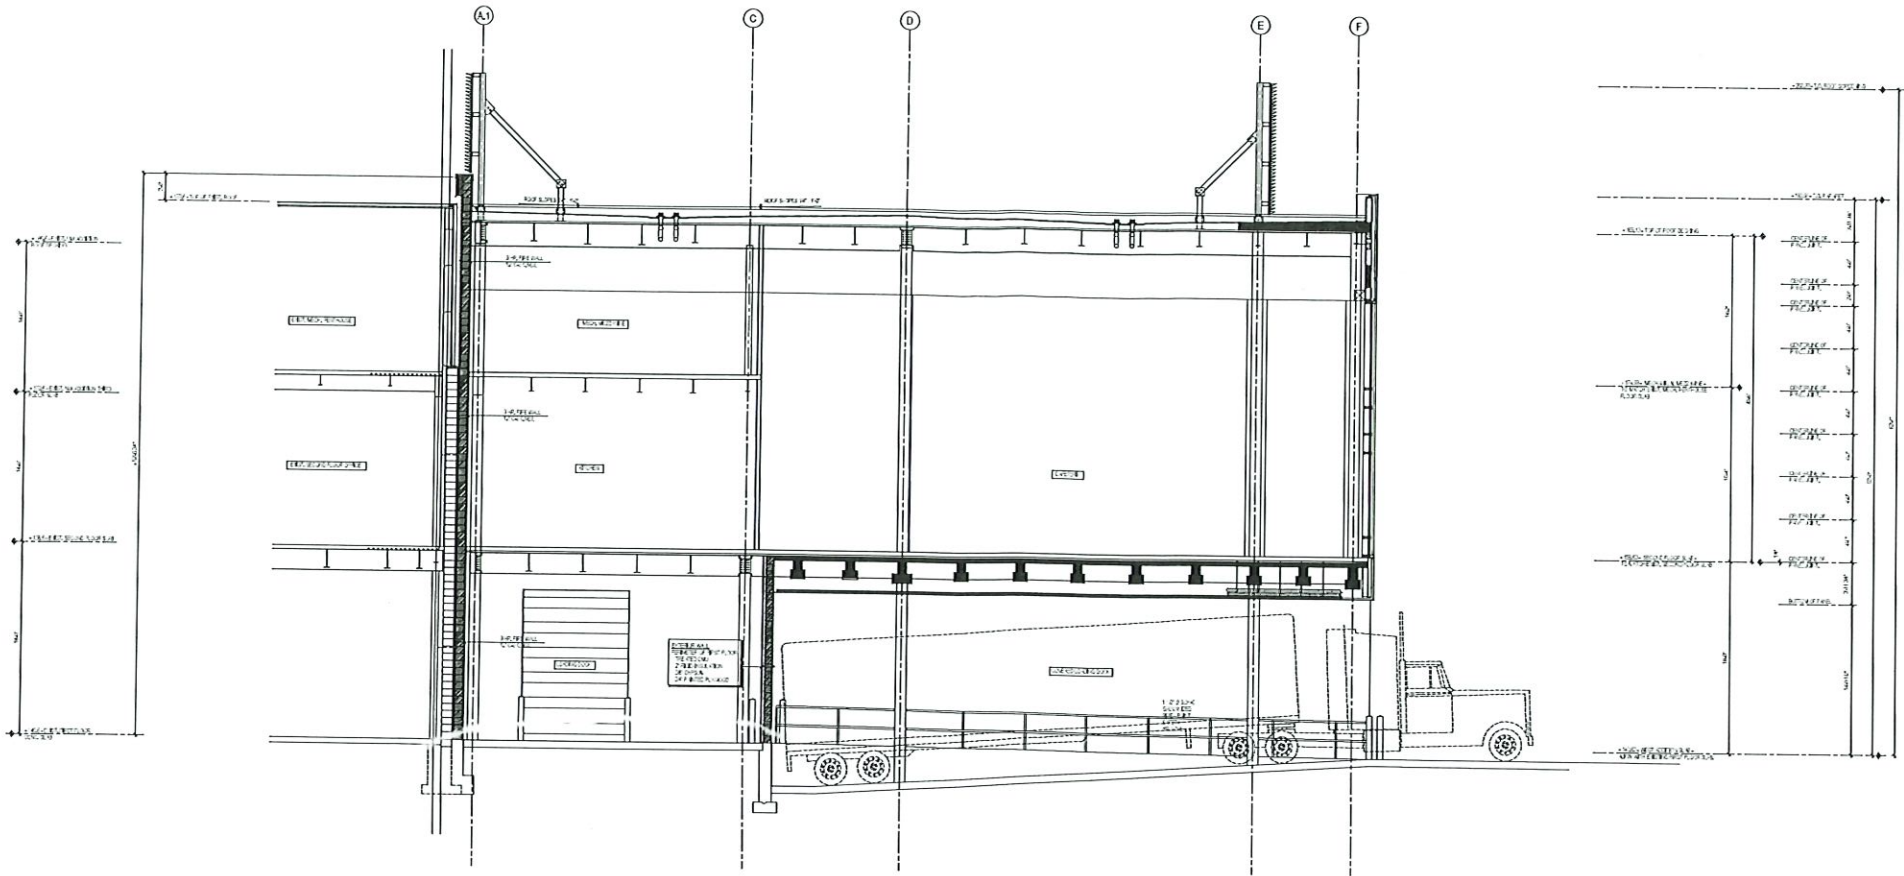

C BUILDING SECTION C
SCALE: 3/16" = 1'-0"

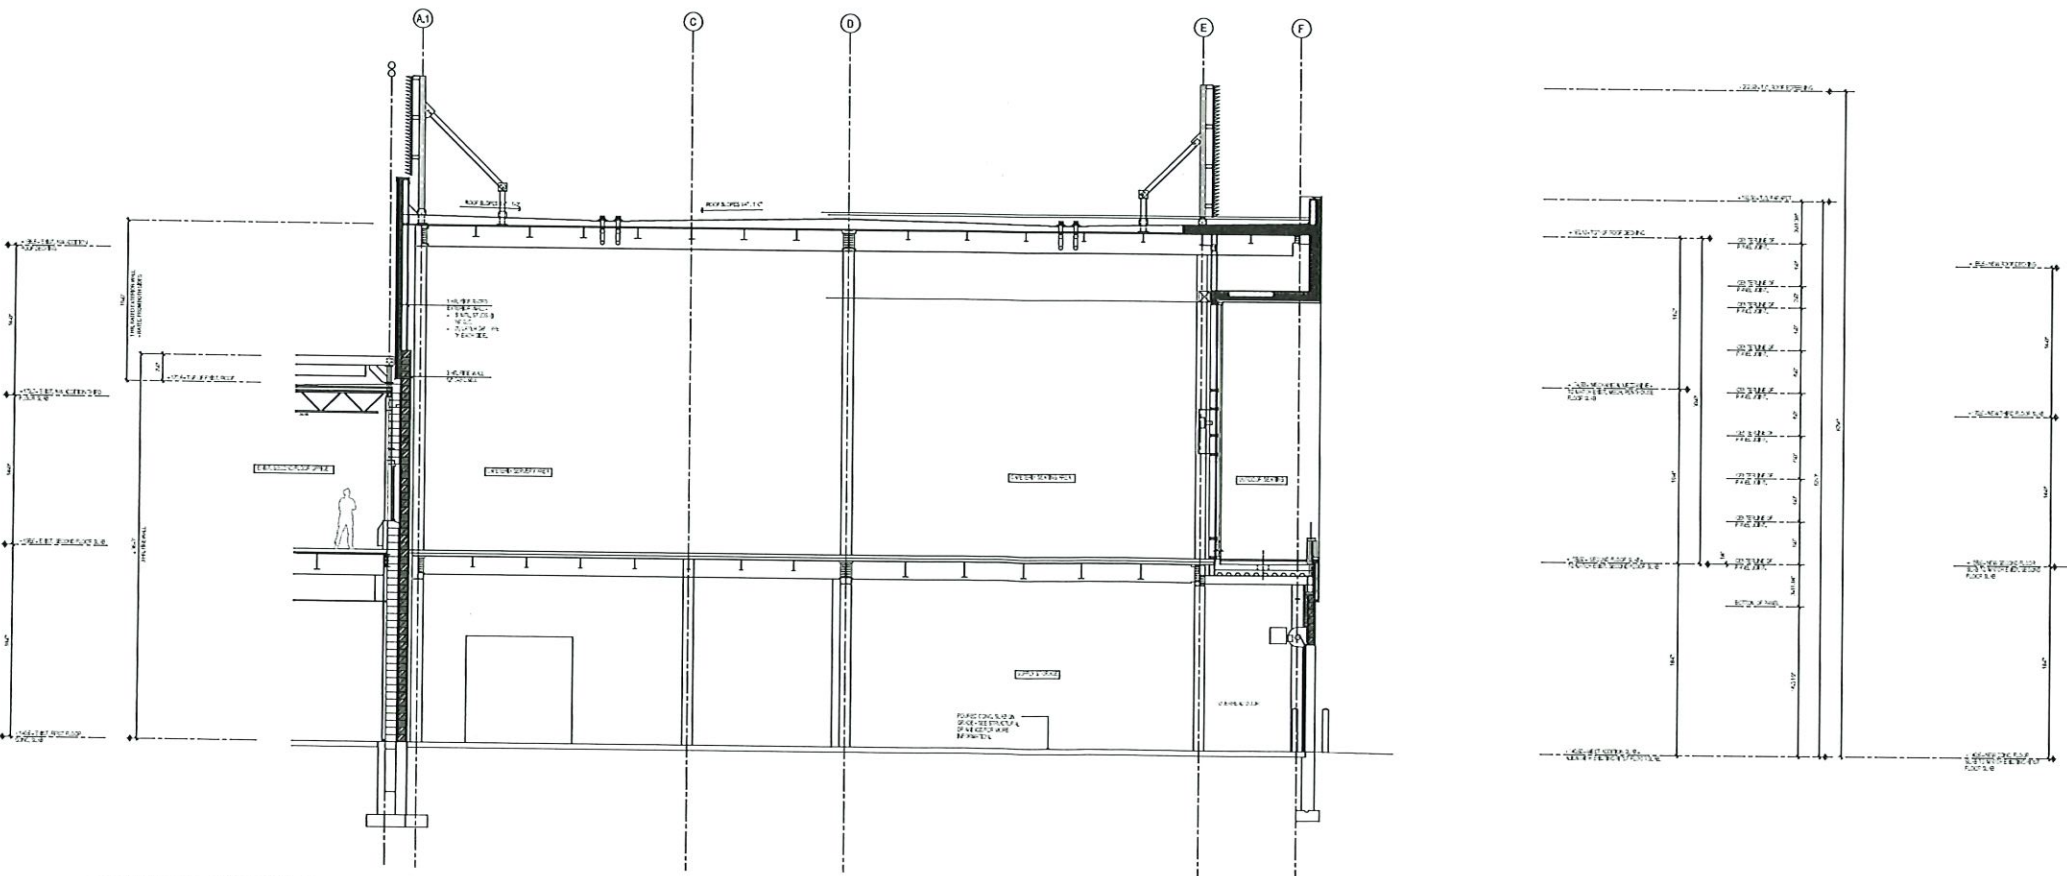

D BUILDING SECTION D
SCALE: 3/16" = 1'-0"

ASML

77 DANBURY ROAD
WILTON, CT 06697

WEST ADDITION

Date: 10.19.21

Scale: 3/16" = 1'-0"

Job No: 21014


Building Title: BUILDING SECTION C&D


COPYRIGHT:

© 2021 ASML. All rights reserved. No part of this drawing may be reproduced without the written permission of ASML. This drawing is the property of ASML and is to be used only for the project and location specified. It is not to be used for any other purpose without the written permission of ASML.

Drawing Number:

DSK617

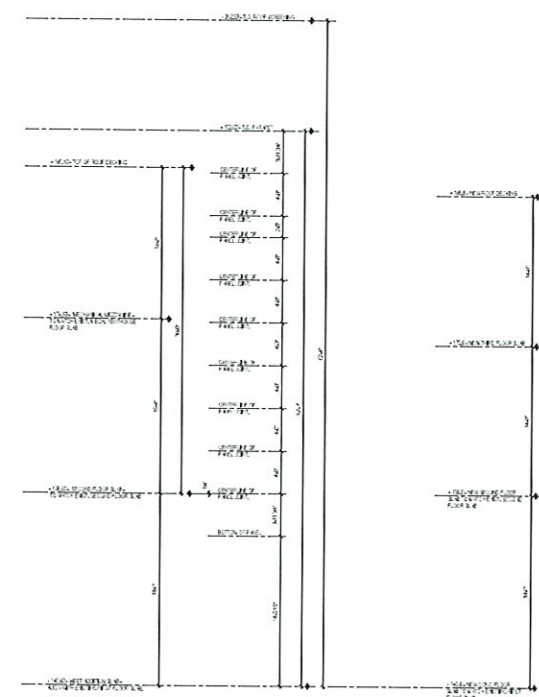

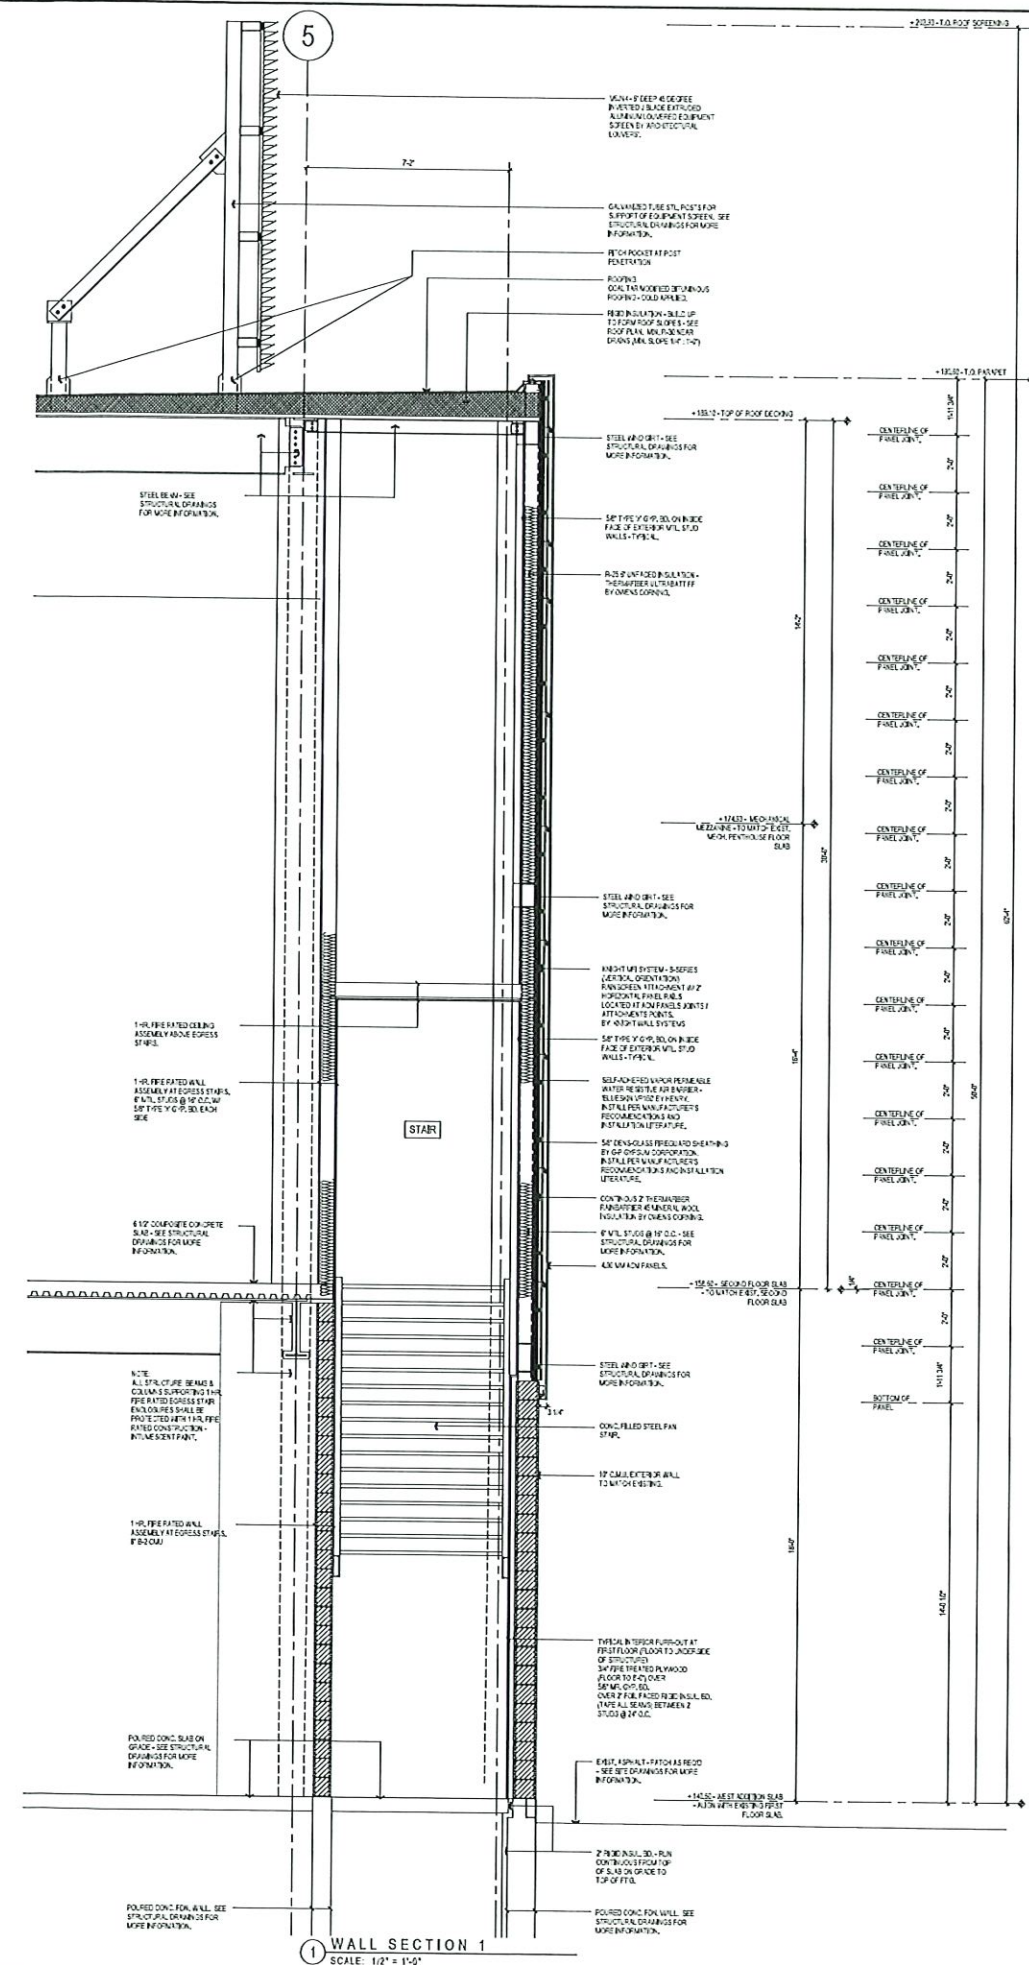

H & R DESIGN
FACILITIES
PLANNERS
DESIGN
INTERIORS
HANNING
51 GORRISON STREET, DANBURY, CT 06810
PH 203-794-7770 FAX 203-794-6553

11/13/21	DESIGN DEVELOPMENT ISSUE
Issue & Revision List	
ASML Ref. No.	


ASML
77 DANBURY ROAD
WILTON, CT 06897
WEST ADDITION

Date	10.13.21	Drawn By	-
Scale	1/2" = 1'-0"	Approved By	S.Y.
JOB No	210114	File	210114.dwg


Drawing Title:
WALL SECTIONS

COPYRIGHT:
© 2021 H & R DESIGN, INC. All rights reserved. No part of this drawing may be reproduced, stored in a retrieval system, or transmitted in any form or by any means, electronic, mechanical, photocopying, recording, or by any information storage and retrieval system, without the prior written permission of H & R DESIGN, INC.

Drawing Number:
DSK620

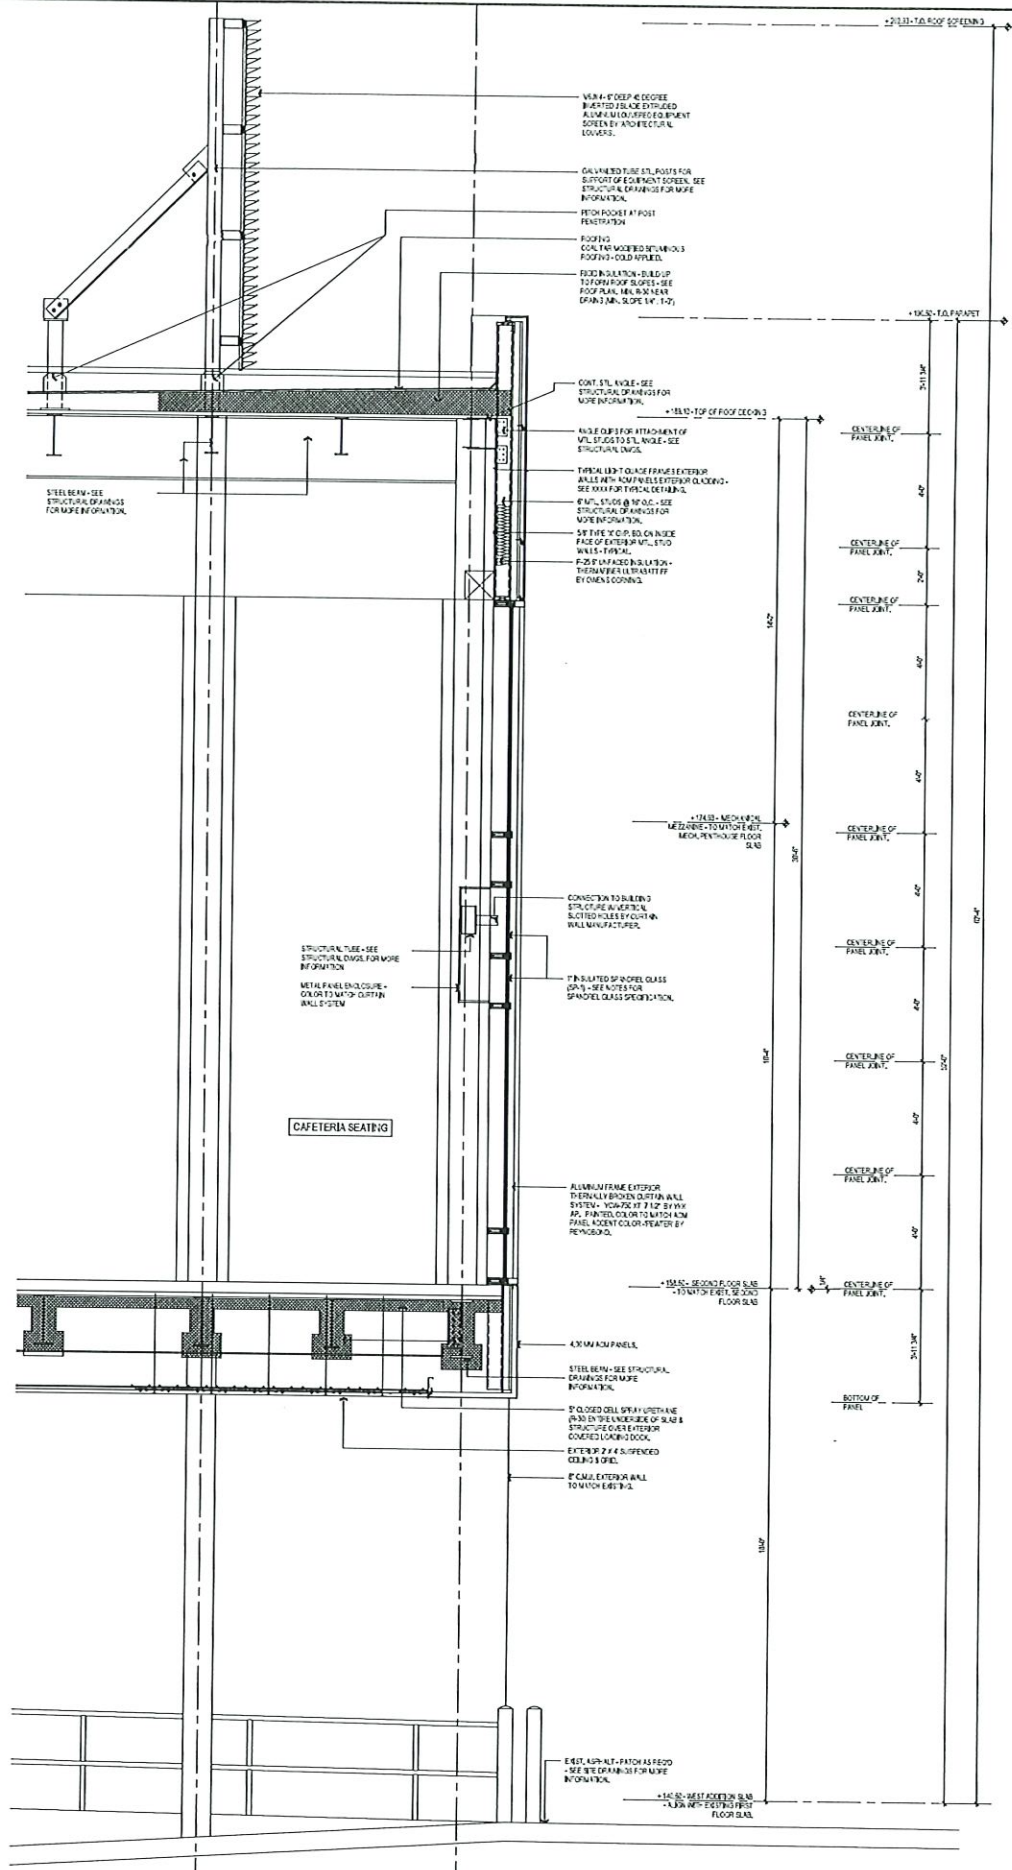

4 WALL SECTION 4
SCALE: 1/2" = 1'-0"

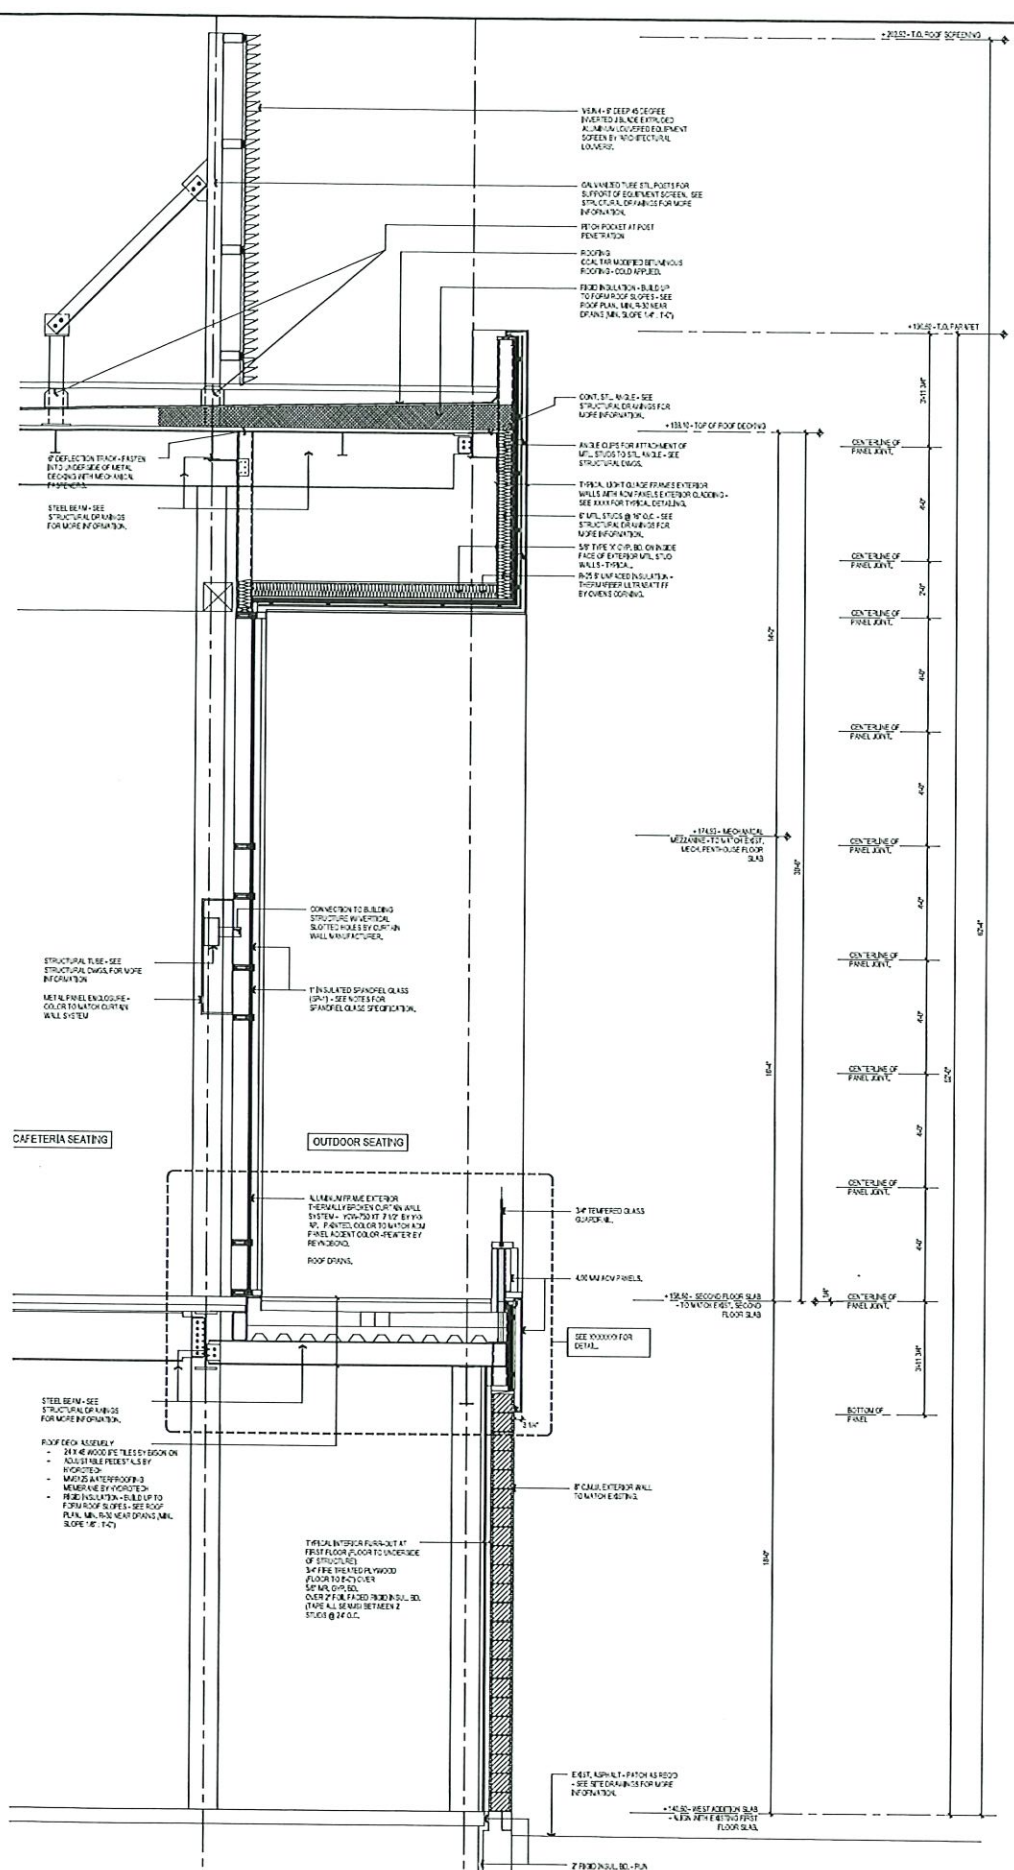

3 WALL SECTION 3
SCALE: 1/2" = 1'-0"

H & R DESIGN
FACILITIES
PLANNERS
LEASING
INTERIORS
PLANNING
81 GORDON STREET, DANBURY, CT 06810
PH 203-794-0100 FAX 203-794-0101

12/13/21 DESIGN DEVELOPMENT ISSUE
Issue & Revision List
ASML Ref. No.

ASML
77 DANBURY ROAD
WILTON, CT 06897
WEST ADDITION

Date 12/13/21 Drawn By
Scale 1/2" = 1'-0" Approved By S.V.
Job No 210014 File
Drawing Title
WALL SECTIONS

COPYRIGHT:
All rights reserved. No part of this drawing may be reproduced or transmitted in any form or by any means electronic or mechanical, including photocopying, recording, or by any information storage and retrieval system, without the prior written permission of H & R Design.

Drawing Number
DSK621