

November 20, 2021

Richard Tomasetti, Chairman Planning and Zoning Commission
c/o Michael Wrinn
Director of Planning and Land-Use Management/Town planner
Town of Wilton, Town Annex 238 Danbury Road.
Wilton, CT 06897

Subject: Phased Opening of 200 Danbury Road, Sharp Hill Square..

Dear Chairman Tomasetti, members of the commission and Mr. Wrinn,

We respectfully request that the commission consider a phased opening of the development known as Sharp Hill Square located at 200 Danbury Road. We are seeking conditional zoning approval, following all inspections and conditional certification of occupancy, of the two western most buildings known as the Raymond Moore house and the "B" building (*see accompanying site plan*).

Due to COVID related shortages and availability of certain structural materials, the construction of the rear building known as the "A" building has been significantly delayed by up to eight months. The Raymond Moore House and the "B" building are nearing completion and we are seeking a phased zoning approval to put these building into productive use and avoid vacant buildings.

Phasing Sequence

The proposed opening schedule includes two Phases: Phase I will include the western buildings known as Raymond Moore house and the "B" building. Both structures consist of commercial occupancies on the first floor and residential on second floor. The target opening is 1/15/22-2/15/22, depending on field circumstances. Phase II includes the A building and target opening is 8/1/22-10/31/22.

All health and safety considerations are of paramount importance and are central to our opening strategy.

Phase I Opening Criteria	
Construction Separation	A construction fence will be placed as shown on the accompanying site plan to segregate the completed structures from the building under construction. The fencing will contain construction signage warning of no trespass. Two secure gates at each end of A building will allow construction vehicles and authorized personnel entrance.
Lighting	The Phase I area will be lighted as shown on attached lighting plan.
Paving	All areas west of the A building within the black line noted on plan, will be paved to provide a solid safe surface for pedestrian and vehicle traffic. <i>Snow plowing will be conducted as normal.</i>

Refuse	A temporary dumpster will be placed as noted on plan with weekly pick-ups.
Fire Access	A fire access plan is included which allows for sufficient access for all buildings. If needed the construction gates providing access to the A building are temporary and not "fixed" allowing quick passage.
Life and Safety	All building and Fire department requirements will be addressed for Phase I opening.
Signage	Any related permanent signage for phase I area will be installed. Directional and Handicap. A temporary Address Sign of not more than 10 square will be placed 5' from property line on RT 7.
Landscaping/Planting	Due to the time of year, plantings will occur as soon as practical in the spring.


Parking

The parking available to the completed structures will be in excess of what is required.

Use	Qty	Required	Provided
Apartments	4	8	8
Visitor Parking (1/2 of apts)	2	2	2
Retail RMH	1,422 sq ft	6	6
Retail "B" building	2,763	14	14
Excess			19
Total		30	49

Respectfully

Patrick Downend
200 Danbury Road, LLC
283 Main Street
Ridgefield, CT 06877
Managing Member

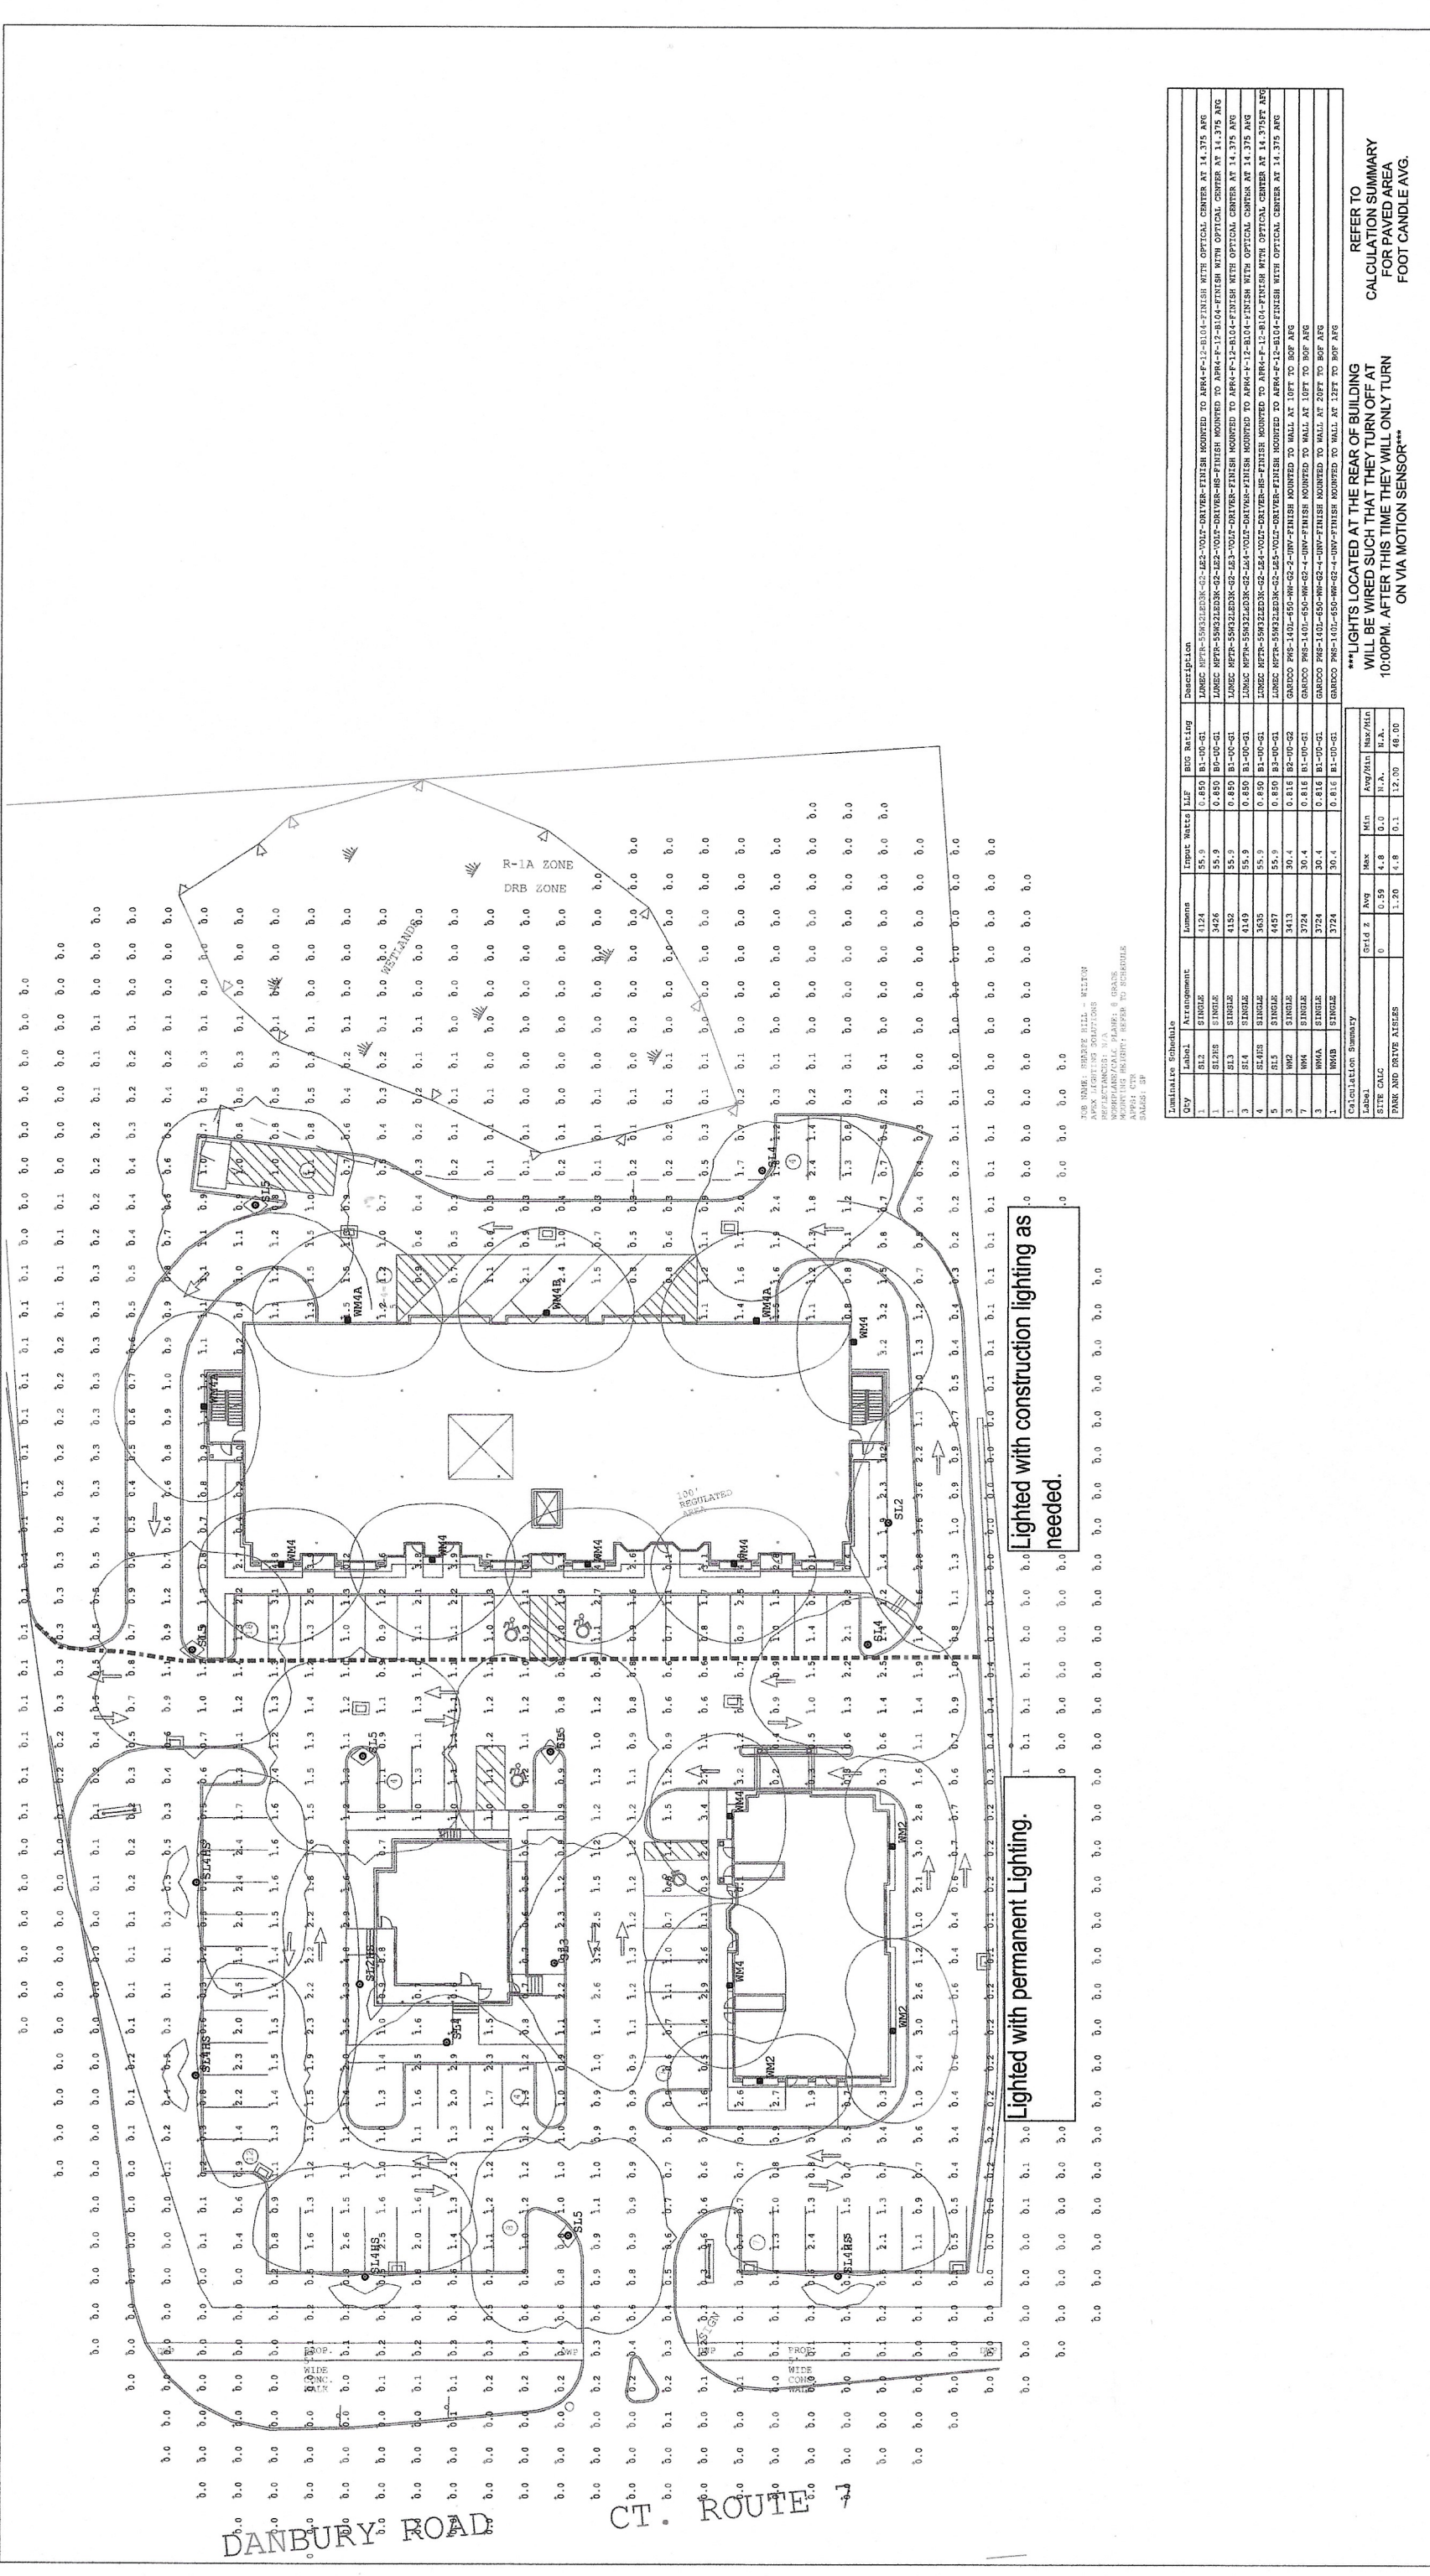

Calculation Summary	
Label	Value
Site Calc	0.59
Park and Drive Aisles	1.20
Min	4.8
Max	4.8
Avg	0.1
Min/Max	12.00
Max/Min	48.00

Calculation Summary	
Label	Value
Site Calc	0.59
Park and Drive Aisles	1.20
Min	4.8
Max	4.8
Avg	0.1
Min/Max	12.00
Max/Min	48.00

Calculation Summary	
Label	Value
Site Calc	0.59
Park and Drive Aisles	1.20
Min	4.8
Max	4.8
Avg	0.1
Min/Max	12.00
Max/Min	48.00

REFER TO CALCULATION SUMMARY FOR PAVED AREA FOOT CANDLE AVG.

PROJECT TITLE:

SHARP HILL
WILTON, CT

DRAWING TITLE:

SITE LIGHTING
PHOTOMETRIC CALCULATION

FILE NAME: SL-2A SHARP HILL - WILTON, CT SITE CALC I-2-2020 CTR.DWG

REVISIONS:

REV. X	XX-XX-XX	XXXX
--------	----------	------


GENERAL DISCLAIMER:

Calculations have been performed according to IES standards and used readily available data. The user is responsible for the accuracy of the input data and the resulting calculations. The user is responsible for the accuracy of the input data and the resulting calculations. The user is responsible for the accuracy of the input data and the resulting calculations.

NOTE TO REVIEWER:

Total Light Loss Factor (LLF) applied at time of design is determined by applying the Lamp Lumen Depreciation (LLD) from current lamp manufacturer's catalog, a Ballast Factor (BF) from current ballast manufacturer's catalog, and an Inverse Color Rendering Index (ICRI) from current lamp manufacturer's catalog. For most common photometric layouts, it is essential that you insist all designers use correct Light Loss Factors.

SL-2.A

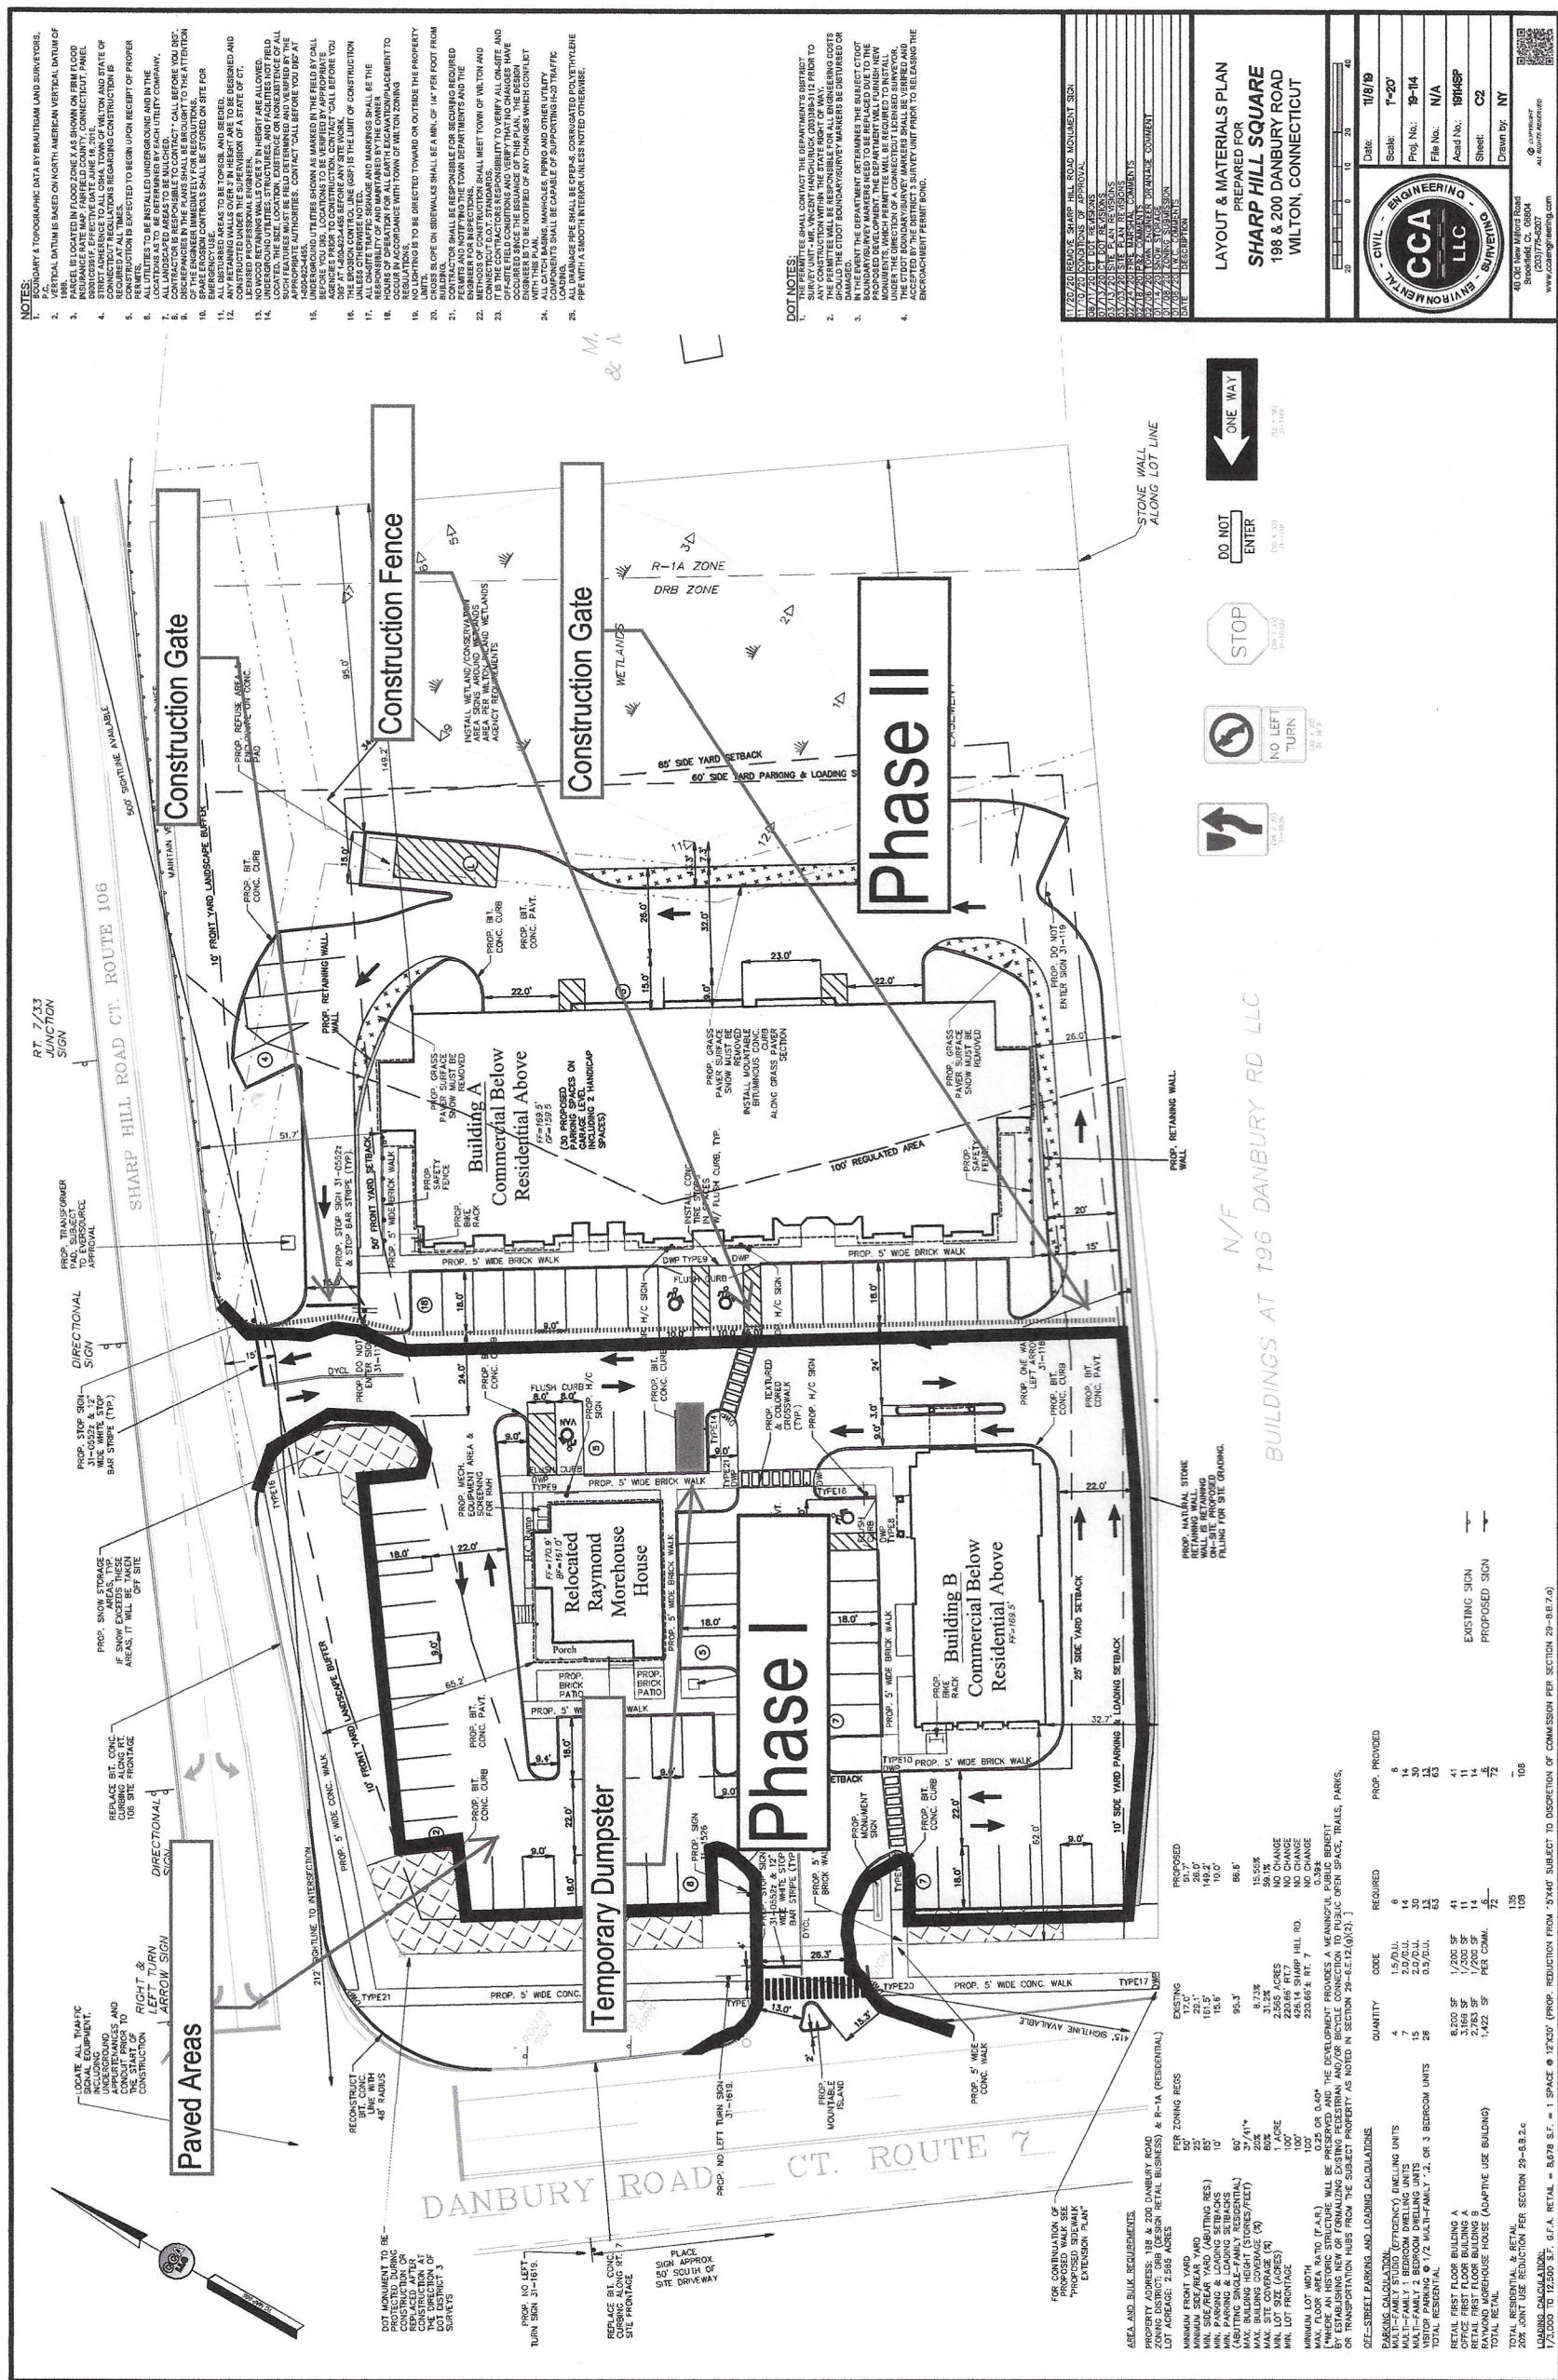

LOT AVERAGE: 2.855 ACRES		PER ZONING REG.	EXISTING	PROPOSED
MINIMUM FRONT YARD	50'	25'	12.0'	51.7'
MINIMUM SIDE/REAR YARD	25'	25'	12.0'	52.0'
MIN. LOT WIDTH	100'	100'	12.0'	52.0'
MIN. PARKING & LOADING SERVICES	10'	10'	15.8'	10.0'
MIN. PARKING & LOADING SERVICES	10'	10'	15.8'	10.0'
MIN. BALANCE HEIGHT (STORES/FEET)	67'	67'	95.3'	86.6'
MIN. BALANCE HEIGHT (STORES/FEET)	67'	67'	95.3'	86.6'
MAX. SITE COVERAGE (%)	80%	80%	31.2%	30.1%
MIN. LOT SIZE (ACRES)	1 ACRE	1 ACRE	2.955 ACRES	NO CHANGE
MIN. LOT FRONTAGE	100'	100'	448.14 SHARP HILL RD.	NO CHANGE
MIN. LOT MOUTH	100'	100'	232.662' RT. 7	NO CHANGE
MIN. LOT MOUTH (TO R.F. 6)	100'	100'	OR 0.64'	NO CHANGE

*WHERE AN EXISTING STRUCTURE WILL BE PRESERVED AND THE DEVELOPMENT PROVIDES A MEANINGFUL PUBLIC BENEFIT
 OR TRANSPORTATION NEEDS FROM THE SUBJECT PROPERTY
 OR TRANSPORTATION NEEDS FROM THE SUBJECT PROPERTY

QUT-SITE PARKING AND LOADING CALCULATIONS

QUANTITY CODE REQUIRED

PINP PROVIDED

PARKING CALCULATIONS						
1. MINIMUM EFFICIENCY DRINKING UNITS	4	15.0/D.U.				8
2. MULTI-FAMILY 1 BEDROOM DRINKING UNITS	7	2.0/D.U.				14
3. MULTI-FAMILY 2 BEDROOM DRINKING UNITS	10	3.0/D.U.				30
4. MULTI-FAMILY 3 BEDROOM UNITS	28	5.0/D.U.				133
5. VISITOR PARKING 1/2 MULTI-FAMILY 2, OR 3 BEDROOM UNITS						13
6. TOTAL RESIDENTIAL						68
7. OFFICE USE	8,500	15				127
8. MULTI-FAMILY 1 BEDROOMS	1,200	15				11
9. OFFICE FIRST FLOOR BUILDING A	3,168	30				11
10. OFFICE FIRST FLOOR BUILDING B	3,168	30				11
11. OFFICE FIRST FLOOR BUILDING C	3,168	30				11
12. OFFICE FIRST FLOOR BUILDING D	3,168	30				11
13. OFFICE FIRST FLOOR BUILDING E	3,168	30				11
14. OFFICE FIRST FLOOR BUILDING F	3,168	30				11
15. OFFICE FIRST FLOOR BUILDING G	3,168	30				11
16. OFFICE FIRST FLOOR BUILDING H	3,168	30				11
17. OFFICE FIRST FLOOR BUILDING I	3,168	30				11
18. OFFICE FIRST FLOOR BUILDING J	3,168	30				11
19. OFFICE FIRST FLOOR BUILDING K	3,168	30				11
20. OFFICE FIRST FLOOR BUILDING L	3,168	30				11
21. OFFICE FIRST FLOOR BUILDING M	3,168	30				11
22. OFFICE FIRST FLOOR BUILDING N	3,168	30				11
23. OFFICE FIRST FLOOR BUILDING O	3,168	30				11
24. OFFICE FIRST FLOOR BUILDING P	3,168	30				11
25. OFFICE FIRST FLOOR BUILDING Q	3,168	30				11
26. OFFICE FIRST FLOOR BUILDING R	3,168	30				11
27. OFFICE FIRST FLOOR BUILDING S	3,168	30				11
28. OFFICE FIRST FLOOR BUILDING T	3,168	30				11
29. OFFICE FIRST FLOOR BUILDING U	3,168	30				11
30. OFFICE FIRST FLOOR BUILDING V	3,168	30				11
31. OFFICE FIRST FLOOR BUILDING W	3,168	30				11
32. OFFICE FIRST FLOOR BUILDING X	3,168	30				11
33. OFFICE FIRST FLOOR BUILDING Y	3,168	30				11
34. OFFICE FIRST FLOOR BUILDING Z	3,168	30				11
35. OFFICE FIRST FLOOR BUILDING AA	3,168	30				11
36. OFFICE FIRST FLOOR BUILDING AB	3,168	30				11
37. OFFICE FIRST FLOOR BUILDING AC	3,168	30				11
38. OFFICE FIRST FLOOR BUILDING AD	3,168	30				11
39. OFFICE FIRST FLOOR BUILDING AE	3,168	30				11
40. OFFICE FIRST FLOOR BUILDING AF	3,168	30				11
41. OFFICE FIRST FLOOR BUILDING AG	3,168	30				11
42. OFFICE FIRST FLOOR BUILDING AH	3,168	30				11
43. OFFICE FIRST FLOOR BUILDING AI	3,168	30				11
44. OFFICE FIRST FLOOR BUILDING AJ	3,168	30				11
45. OFFICE FIRST FLOOR BUILDING AK	3,168	30				11
46. OFFICE FIRST FLOOR BUILDING AL	3,168	30				11
47. OFFICE FIRST FLOOR BUILDING AM	3,168	30				11
48. OFFICE FIRST FLOOR BUILDING AN	3,168	30				11
49. OFFICE FIRST FLOOR BUILDING AO	3,168	30				11
50. OFFICE FIRST FLOOR BUILDING AP	3,168	30				11
51. OFFICE FIRST FLOOR BUILDING AQ	3,168	30				11
52. OFFICE FIRST FLOOR BUILDING AR	3,168	30				11
53. OFFICE FIRST FLOOR BUILDING AS	3,168	30				11
54. OFFICE FIRST FLOOR BUILDING AT	3,168	30				11
55. OFFICE FIRST FLOOR BUILDING AU	3,168	30				11
56. OFFICE FIRST FLOOR BUILDING AV	3,168	30				11
57. OFFICE FIRST FLOOR BUILDING AW	3,168	30				11
58. OFFICE FIRST FLOOR BUILDING AX	3,168	30				11
59. OFFICE FIRST FLOOR BUILDING AY	3,168	30				11
60. OFFICE FIRST FLOOR BUILDING AZ	3,168	30				11
61. OFFICE FIRST FLOOR BUILDING BA	3,168	30				11
62. OFFICE FIRST FLOOR BUILDING BB	3,168	30				11
63. OFFICE FIRST FLOOR BUILDING BC	3,168	30				11
64. OFFICE FIRST FLOOR BUILDING BD	3,168	30				11
65. OFFICE FIRST FLOOR BUILDING BE	3,168	30				11
66. OFFICE FIRST FLOOR BUILDING BF	3,168	30				11
67. OFFICE FIRST FLOOR BUILDING BG	3,168	30				11
68. OFFICE FIRST FLOOR BUILDING BH	3,168	30				11
69. OFFICE FIRST FLOOR BUILDING BI	3,168	30				11
70. OFFICE FIRST FLOOR BUILDING BJ	3,168	30				11
71. OFFICE FIRST FLOOR BUILDING BK	3,168	30				11
72. OFFICE FIRST FLOOR BUILDING BL	3,168	30				11
73. OFFICE FIRST FLOOR BUILDING BM	3,168	30				11
74. OFFICE FIRST FLOOR BUILDING BN	3,168	30				11
75. OFFICE FIRST FLOOR BUILDING BO	3,168	30				11
76. OFFICE FIRST FLOOR BUILDING BP	3,168	30				11
77. OFFICE FIRST FLOOR BUILDING BQ	3,168	30				11
78. OFFICE FIRST FLOOR BUILDING BR	3,168	30				11
79. OFFICE FIRST FLOOR BUILDING BS	3,168	30				11
80. OFFICE FIRST FLOOR BUILDING BT	3,168	30				11
81. OFFICE FIRST FLOOR BUILDING BU	3,168	30				11
82. OFFICE FIRST FLOOR BUILDING BV	3,168	30				11
83. OFFICE FIRST FLOOR BUILDING BW	3,168	30				11
84. OFFICE FIRST FLOOR BUILDING BX	3,168	30				11
85. OFFICE FIRST FLOOR BUILDING BY	3,168	30				11
86. OFFICE FIRST FLOOR BUILDING BZ	3,168	30				11
87. OFFICE FIRST FLOOR BUILDING CA	3,168	30				11
88. OFFICE FIRST FLOOR BUILDING CB	3,168	30				11
89. OFFICE FIRST FLOOR BUILDING CC	3,168	30				11
90. OFFICE FIRST FLOOR BUILDING CD	3,168	30				11
91. OFFICE FIRST FLOOR BUILDING CE	3,168	30				11
92. OFFICE FIRST FLOOR BUILDING CF	3,168	30				11
93. OFFICE FIRST FLOOR BUILDING CG	3,168	30				11
94. OFFICE FIRST FLOOR BUILDING CH	3,168	30				11
95. OFFICE FIRST FLOOR BUILDING CI	3,168	30				11
96. OFFICE FIRST FLOOR BUILDING CJ	3,168	30				11
97. OFFICE FIRST FLOOR BUILDING CK	3,168	30				11
98. OFFICE FIRST FLOOR BUILDING CL	3,168	30				11
99. OFFICE FIRST FLOOR BUILDING CM	3,168	30				11
100. OFFICE FIRST FLOOR BUILDING CN	3,168	30				11
101. OFFICE FIRST FLOOR BUILDING CO	3,168	30				11
102. OFFICE FIRST FLOOR BUILDING CP	3,168	30				11
103. OFFICE FIRST FLOOR BUILDING CQ	3,168	30				11
104. OFFICE FIRST FLOOR BUILDING CR	3,168	30				11
105. OFFICE FIRST FLOOR BUILDING CS	3,168	30				11
106. OFFICE FIRST FLOOR BUILDING CT	3,168	30				11
107. OFFICE FIRST FLOOR BUILDING CU	3,168	30				11
108. OFFICE FIRST FLOOR BUILDING CV	3,168	30				11
109. OFFICE FIRST FLOOR BUILDING CW	3,168	30				11
110. OFFICE FIRST FLOOR BUILDING CX	3,168	30				11
111. OFFICE FIRST FLOOR BUILDING CY	3,168	30				11
112. OFFICE FIRST FLOOR BUILDING CZ	3,168	30				11
113. OFFICE FIRST FLOOR BUILDING DA	3,168	30				11
114. OFFICE FIRST FLOOR BUILDING DB	3,168	30				11
115. OFFICE FIRST FLOOR BUILDING DC	3,168	30				11
116. OFFICE FIRST FLOOR BUILDING DD	3,168	30				11
117. OFFICE FIRST FLOOR BUILDING DE	3,168	30				11
118. OFFICE FIRST FLOOR BUILDING DF	3,168	30				11
119. OFFICE FIRST FLOOR BUILDING DG	3,168	30				11
120. OFFICE FIRST FLOOR BUILDING DH	3,168	30				11
121. OFFICE FIRST FLOOR BUILDING DI	3,168	30				11
122. OFFICE FIRST FLOOR BUILDING DJ	3,168	30				11
123. OFFICE FIRST FLOOR BUILDING DK	3,168	30				11
124. OFFICE FIRST FLOOR BUILDING DL	3,168	30				11
125. OFFICE FIRST FLOOR BUILDING DM	3,168	30				11
126. OFFICE FIRST FLOOR BUILDING DN	3,168	30				11
127. OFFICE FIRST FLOOR BUILDING DO	3,168	30				11
128. OFFICE FIRST FLOOR BUILDING DP	3,168	30				11
129. OFFICE FIRST FLOOR BUILDING DQ	3,168	30				11
130. OFFICE FIRST FLOOR BUILDING DR	3,168	30				11
131. OFFICE FIRST FLOOR BUILDING DS	3,168	30				11
132. OFFICE FIRST FLOOR BUILDING DT	3,168	30				11
133. OFFICE FIRST FLOOR BUILDING DU	3,168	30				11
134. OFFICE FIRST FLOOR BUILDING DV	3,168	30				11
135. OFFICE FIRST FLOOR BUILDING DW	3,168	30				11
136. OFFICE FIRST FLOOR BUILDING DX	3,168	30				11
137. OFFICE FIRST FLOOR BUILDING DY	3,168	30				11
138. OFFICE FIRST FLOOR BUILDING DZ	3,168	30				11
139. OFFICE FIRST FLOOR BUILDING EA	3,168	30				11
140. OFFICE FIRST FLOOR BUILDING EB	3,168	30				11
141. OFFICE FIRST FLOOR BUILDING EC	3,168	30				11
142. OFFICE FIRST FLOOR BUILDING ED	3,168	30				11
143. OFFICE FIRST FLOOR BUILDING EE	3,168	30				11
144. OFFICE FIRST FLOOR BUILDING EF	3,168	30				11
145. OFFICE FIRST FLOOR BUILDING EG	3,168	30				11
146. OFFICE FIRST FLOOR BUILDING EH	3,168	30				11
147. OFFICE FIRST FLOOR BUILDING EI	3,168	30				11
148. OFFICE FIRST FLOOR BUILDING EJ	3,168	30				11
149. OFFICE FIRST FLOOR BUILDING EK	3,168	30				11
150. OFFICE FIRST FLOOR BUILDING EL	3,168	30				11
151. OFFICE FIRST FLOOR BUILDING EM	3,168	30				11
152. OFFICE FIRST FLOOR BUILDING EN	3,168	30				11
153. OFFICE FIRST FLOOR BUILDING EO	3,168	30				11
154. OFFICE FIRST FLOOR BUILDING EP	3,168	30				11
155. OFFICE FIRST FLOOR BUILDING EQ	3,168	30				11
156. OFFICE FIRST FLOOR BUILDING ER	3,168	30				11
157. OFFICE FIRST FLOOR BUILDING ES	3,168	30				11
158. OFFICE FIRST FLOOR BUILDING ET	3,168	30				11
159. OFFICE FIRST FLOOR BUILDING EU	3,168	30				11
160. OFFICE FIRST FLOOR BUILDING EV	3,168	30				11
161. OFFICE FIRST FLOOR BUILDING EW	3,168	30				11
162. OFFICE FIRST FLOOR BUILDING EX	3,168	30				11
163. OFFICE FIRST FLOOR BUILDING EY	3,168	30				11
164. OFFICE FIRST FLOOR BUILDING EZ	3,168	30				11
165. OFFICE FIRST FLOOR BUILDING FA	3,168	30				11
166. OFFICE FIRST FLOOR BUILDING FB	3,168	30				11
167. OFFICE FIRST FLOOR BUILDING FC	3,168	30				11
168. OFFICE FIRST FLOOR BUILDING FD	3,168	30				11
169. OFFICE FIRST FLOOR BUILDING FE	3,168	30				11
170. OFFICE FIRST FLOOR BUILDING FF	3,168	30				11
171. OFFICE FIRST FLOOR BUILDING FG	3,168	30				11
172. OFFICE FIRST FLOOR BUILDING FH	3,168	30				11
173. OFFICE FIRST FLOOR BUILDING FI	3,168	30				11
174. OFFICE FIRST FLOOR BUILDING FJ	3,168	30				11
175. OFFICE FIRST FLOOR BUILDING FK	3,168	30				11
176. OFFICE FIRST FLOOR BUILDING FL	3,168	30				11
177. OFFICE FIRST FLOOR BUILDING FM	3,168	30				11
178. OFFICE FIRST FLOOR BUILDING FN	3,168	30				11
179. OFFICE FIRST FLOOR BUILDING FO	3,168	30				11
180. OFFICE FIRST FLOOR BUILDING FP	3,168	30				11
181. OFFICE FIRST FLOOR BUILDING FQ	3,168	30				11
182. OFFICE FIRST FLOOR BUILDING FR	3,168	30				11
183. OFFICE FIRST FLOOR BUILDING FS	3,168	30				11
184. OFFICE FIRST FLOOR BUILDING FT	3,168	30				11
185. OFFICE FIRST FLOOR BUILDING FU	3,168	30				11
186. OFFICE FIRST FLOOR BUILDING FV	3,168	30				11
187. OFFICE FIRST FLOOR BUILDING FW	3,168	30				11
188. OFFICE FIRST FLOOR BUILDING FX	3,168	30				11
189. OFFICE FIRST FLOOR BUILDING FY	3,168	30				11
190. OFFICE FIRST FLOOR BUILDING FZ	3,168	30				11
191. OFFICE FIRST FLOOR BUILDING GA	3,168	30				11
192. OFFICE FIRST FLOOR BUILDING GB	3,168	30				11
193. OFFICE FIRST FLOOR BUILDING GC	3,168	30				11
194. OFFICE FIRST FLOOR BUILDING GD	3,168	30				11
195. OFFICE FIRST FLOOR BUILDING GE	3,168	30				11
196. OFFICE FIRST FLOOR BUILDING GF	3,168	30				11
197. OFFICE FIRST FLOOR BUILDING GG	3,168	30				11
198. OFFICE FIRST FLOOR BUILDING GH	3,168	30				11
199. OFFICE FIRST FLOOR BUILDING GI	3,168	30				11
200. OFFICE FIRST FLOOR BUILDING GJ	3,168	30				11
201. OFFICE FIRST FLOOR BUILDING GK	3,168	30				11
202. OFFICE FIRST FLOOR BUILDING GL	3,168	30				11
203. OFFICE FIRST FLOOR BUILDING GM	3,168	30				11
204. OFFICE FIRST FLOOR BUILDING GN	3,168	30				11
205. OFFICE FIRST FLOOR BUILDING GO	3,168	30				11
206. OFFICE FIRST FLOOR BUILDING GP	3,168	30				11
207. OFFICE FIRST FLOOR BUILDING GQ	3,168	30				11
208. OFFICE FIRST FLOOR BUILDING GR	3,168	30				11
209. OFFICE FIRST FLOOR BUILDING GS	3,168	30				11
210. OFFICE FIRST FLOOR BUILDING GT	3,168	30				11
211. OFFICE FIRST FLOOR BUILDING GU	3,168	30				11
212. OFFICE FIRST FLOOR BUILDING GV	3,168	30				11
213. OFFICE FIRST FLOOR BUILDING GW	3,168	30				11
214. OFFICE FIRST FLOOR BUILDING GX	3,168	30				11
215. OFFICE FIRST FLOOR BUILDING GY	3,168	30				11
216. OFFICE FIRST FLOOR BUILDING GZ	3,168	30				11
217. OFFICE FIRST FLOOR BUILDING HA	3,168	30				11
218. OFFICE FIRST FLOOR BUILDING HB	3,168	30				11
219. OFFICE FIRST FLOOR BUILDING						


LOADING CALCULATION:
1/3,000 TO 12,500 S.F. G.F. RETAIL = 8,078 S.F. = 1 SPACE @ 12'X30' (PROP. REDUCTION FROM 5'X40' SUBJECT TO DISCRETION OF COMMISSION PER SECTION 29-08.7.d)

DATE	DESCRIPTION
01/20/20	REMOVE SHARP HILL ROAD MONUMENT SIGN
01/20/20	CONDITIONS OF APPROVAL
08/17/20	DOT REVISIONS
07/15/20	DOT REVISIONS
07/15/20	DOT REVISIONS
03/03/20	SITE PLAN REVISIONS
02/24/20	PRELIMINARY COMMENTS
02/18/20	DOT COMMENTS
02/18/20	DOT COMMENTS
02/18/20	TOWN ENGINEER DRAINAGE COMMENT
02/08/20	CONTRACTOR CONCERN
02/08/20	CONTRACTOR CONCERN
02/08/20	T.W.C. COMMENTS

LAYOUT & MATERIALS PLAN
PREPARED FOR
SHARP HILL SQUARE
198 & 200 DANBURY ROAD
WILTON, CONNECTICUT

25	20	15	10	5	0
Date: 11/8/19					
Scale: 1"=20'					
Proj. No.: 19-114					
File No.: N/A					
Acad No.: 19148P					
Sheet: C2					
Drawn by: NY					

www.cca-engineering.com
 40 CG New Milford Road
 Suite 200
 New Milford, CT 06854
 (203) 771-2707

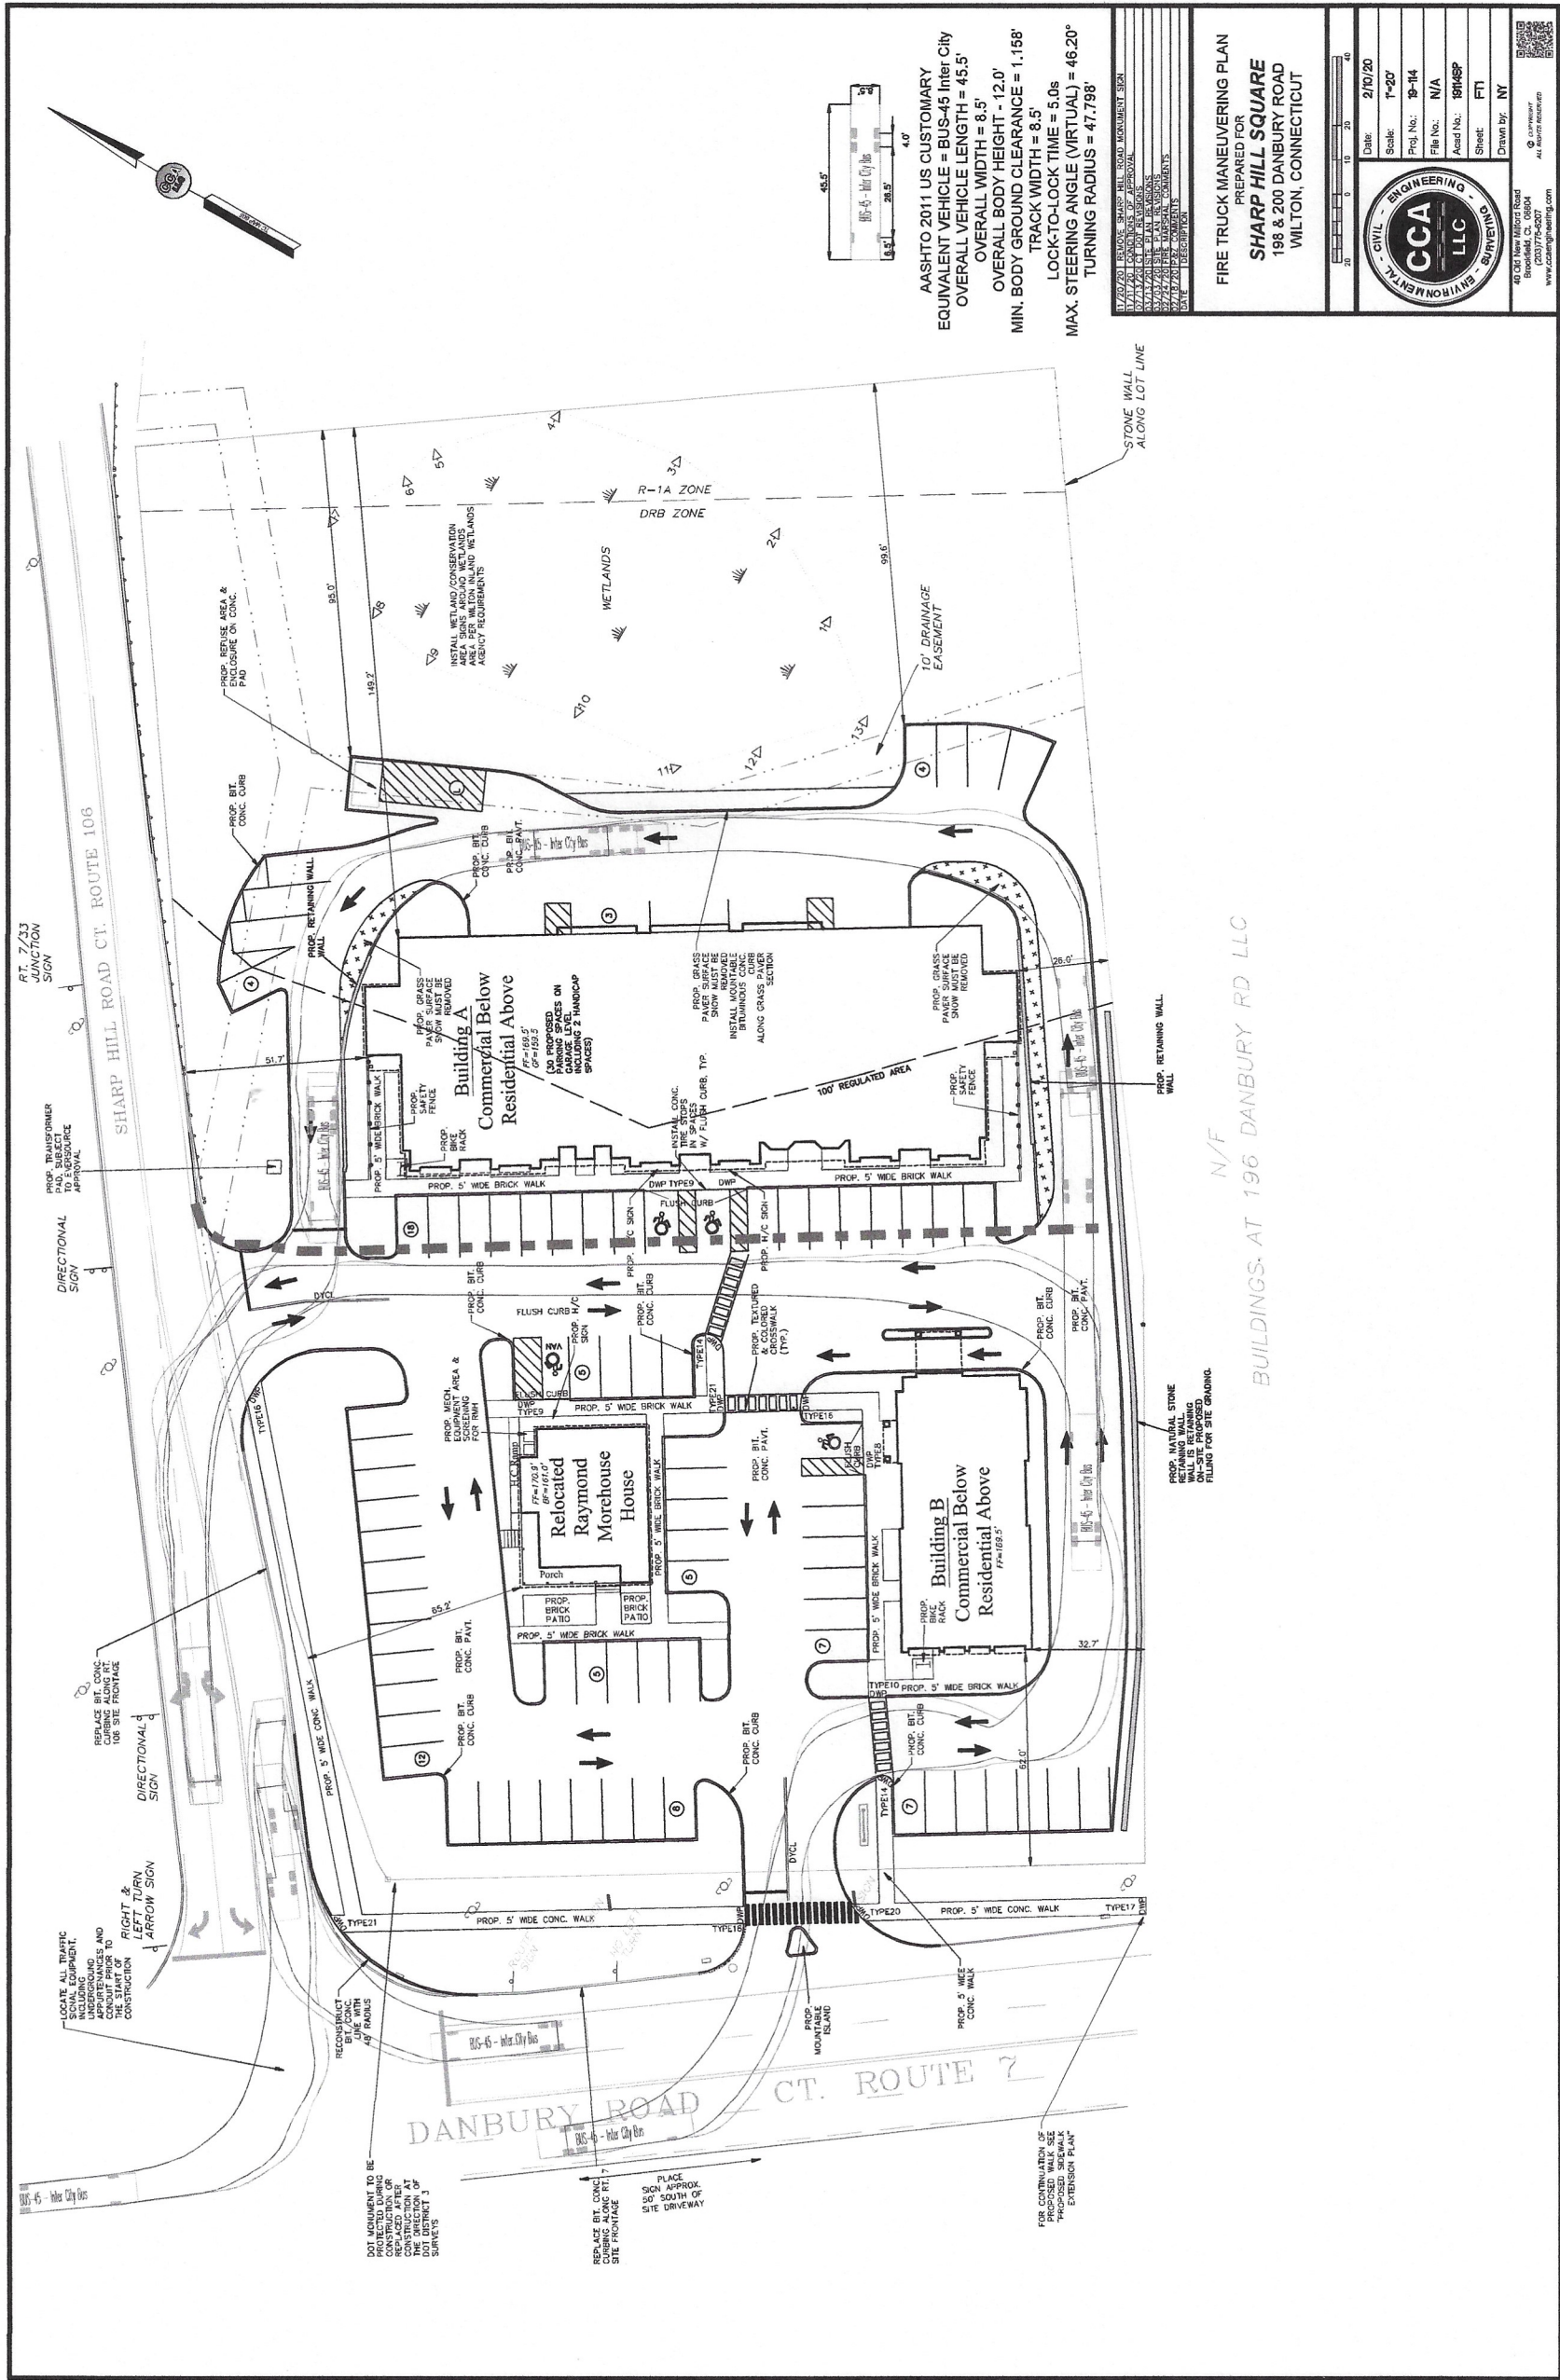

AASHTO 2011 US CUSTOMARY
EQUIVALENT VEHICLE = BUS-45 Inter City
OVERALL VEHICLE LENGTH = 45.5'
OVERALL WIDTH = 8.5'
OVERALL BODY HEIGHT = 12.0'
MIN. BODY GROUND CLEARANCE = 1.158'
LOCK-TO-LOCK TIME = 5.0s
MAX. STEERING ANGLE (VIRTUAL) = 46.20°
TURNING RADIUS = 47.798'

DATE	DESCRIPTION
11/17/20	REVISIONS TO STANDARD MANUEVERING PLAN
11/17/20	REVISIONS TO STANDARD MANUEVERING PLAN
FIRE TRUCK MANUEVERING PLAN
PREPARED FOR
SHARP HILL SQUARE
198 & 200 DANBURY ROAD
WILTON, CONNECTICUT

CCA
CIVIL
ENGINEERING
LLC
ENVIRONMENTAL
SUPERVISOR

DATE: 2/10/20
SCALE: 1"=20'
PROJ. NO.: 19-14
FILE NO.: N/A
ACCT. NO.: 19146P
SHEET: FT1
DRAWN BY: NY

40 Old New Milford Road
Brookfield, CT 06804
(203) 775-0000
www.cca-engineering.com